


**NOTES:**

- FOR LEGEND, ABBREVIATIONS AND GENERAL NOTES SEE SHEETS WA-H-001 AND WA-H-002.
- SEE INPUT/OUTPUT SUMMARY SHEET WA-H-541 FOR ALARMS AND EQUIPMENT CONTROL.

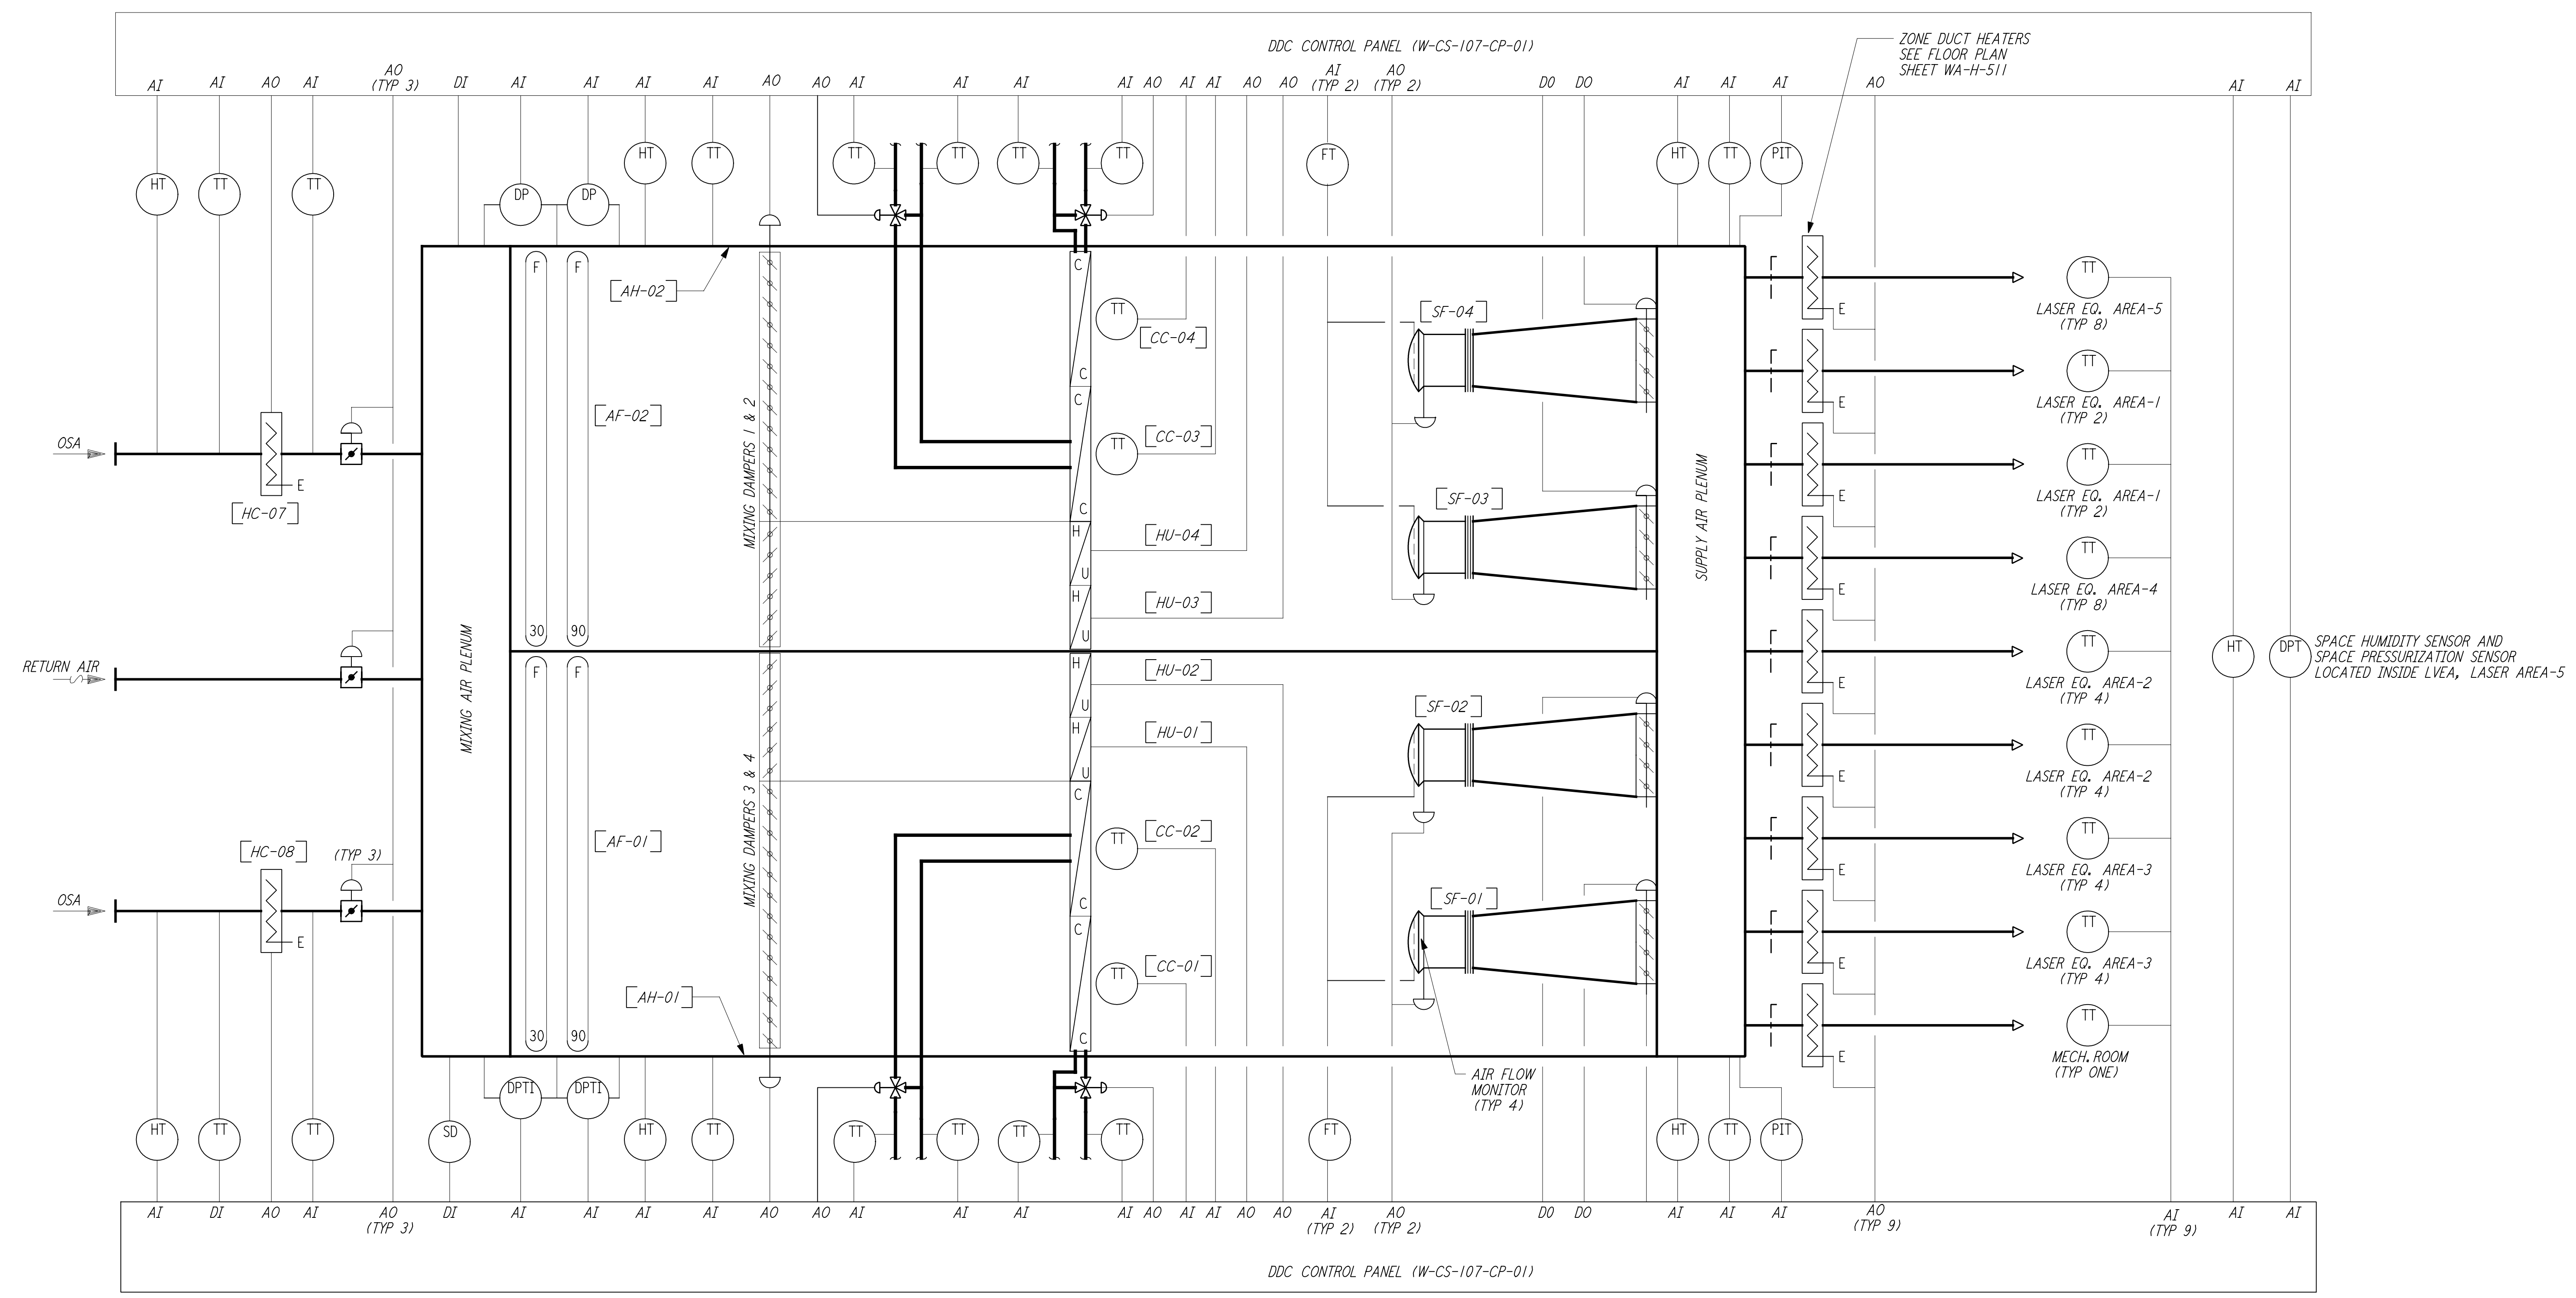

LVEA AIR FLOW & CONTROL DIAGRAM (AH-01 & AH-02)

This document and the design it covers are the property of PARSONS. They are loaned only with the borrower's expressed written agreement that they will not be reproduced, copied, loaned, exhibited, or used in any other way, except by written consent from PARSONS to the borrower.

NO.	DATE	BY	CHKD	ENGR	PROJ	DESCRIPTION
1	5-15-98	CP				ISSUED FOR AS-BUILT

ISSUED FOR CONSTRUCTION  
 DRAWN CLP 6-24-96  
 CHECKED  
 ENGINEER  
 PROJ  
**AS-BUILT DRAWINGS**



LASER INTERFEROMETER GRAVITATIONAL-WAVE OBSERVATORY SITE NO. 1 - HANFORD, WASHINGTON			
TITLE	SCALE	CONTRACT NUMBER	PROJECT NUMBER
HVAC CORNER STATION AIR FLOW DIAGRAMS	NONE	PP150969	8094
SHEET NUMBER <b>WA-H-521</b>		REVISIONS	

LIGO-D960384-01-0