


NOTE:

1. FOR SPECIFICATIONS SEE SPECIFICATION SECTION 16742 TELEPHONE AND DATA CABLE.

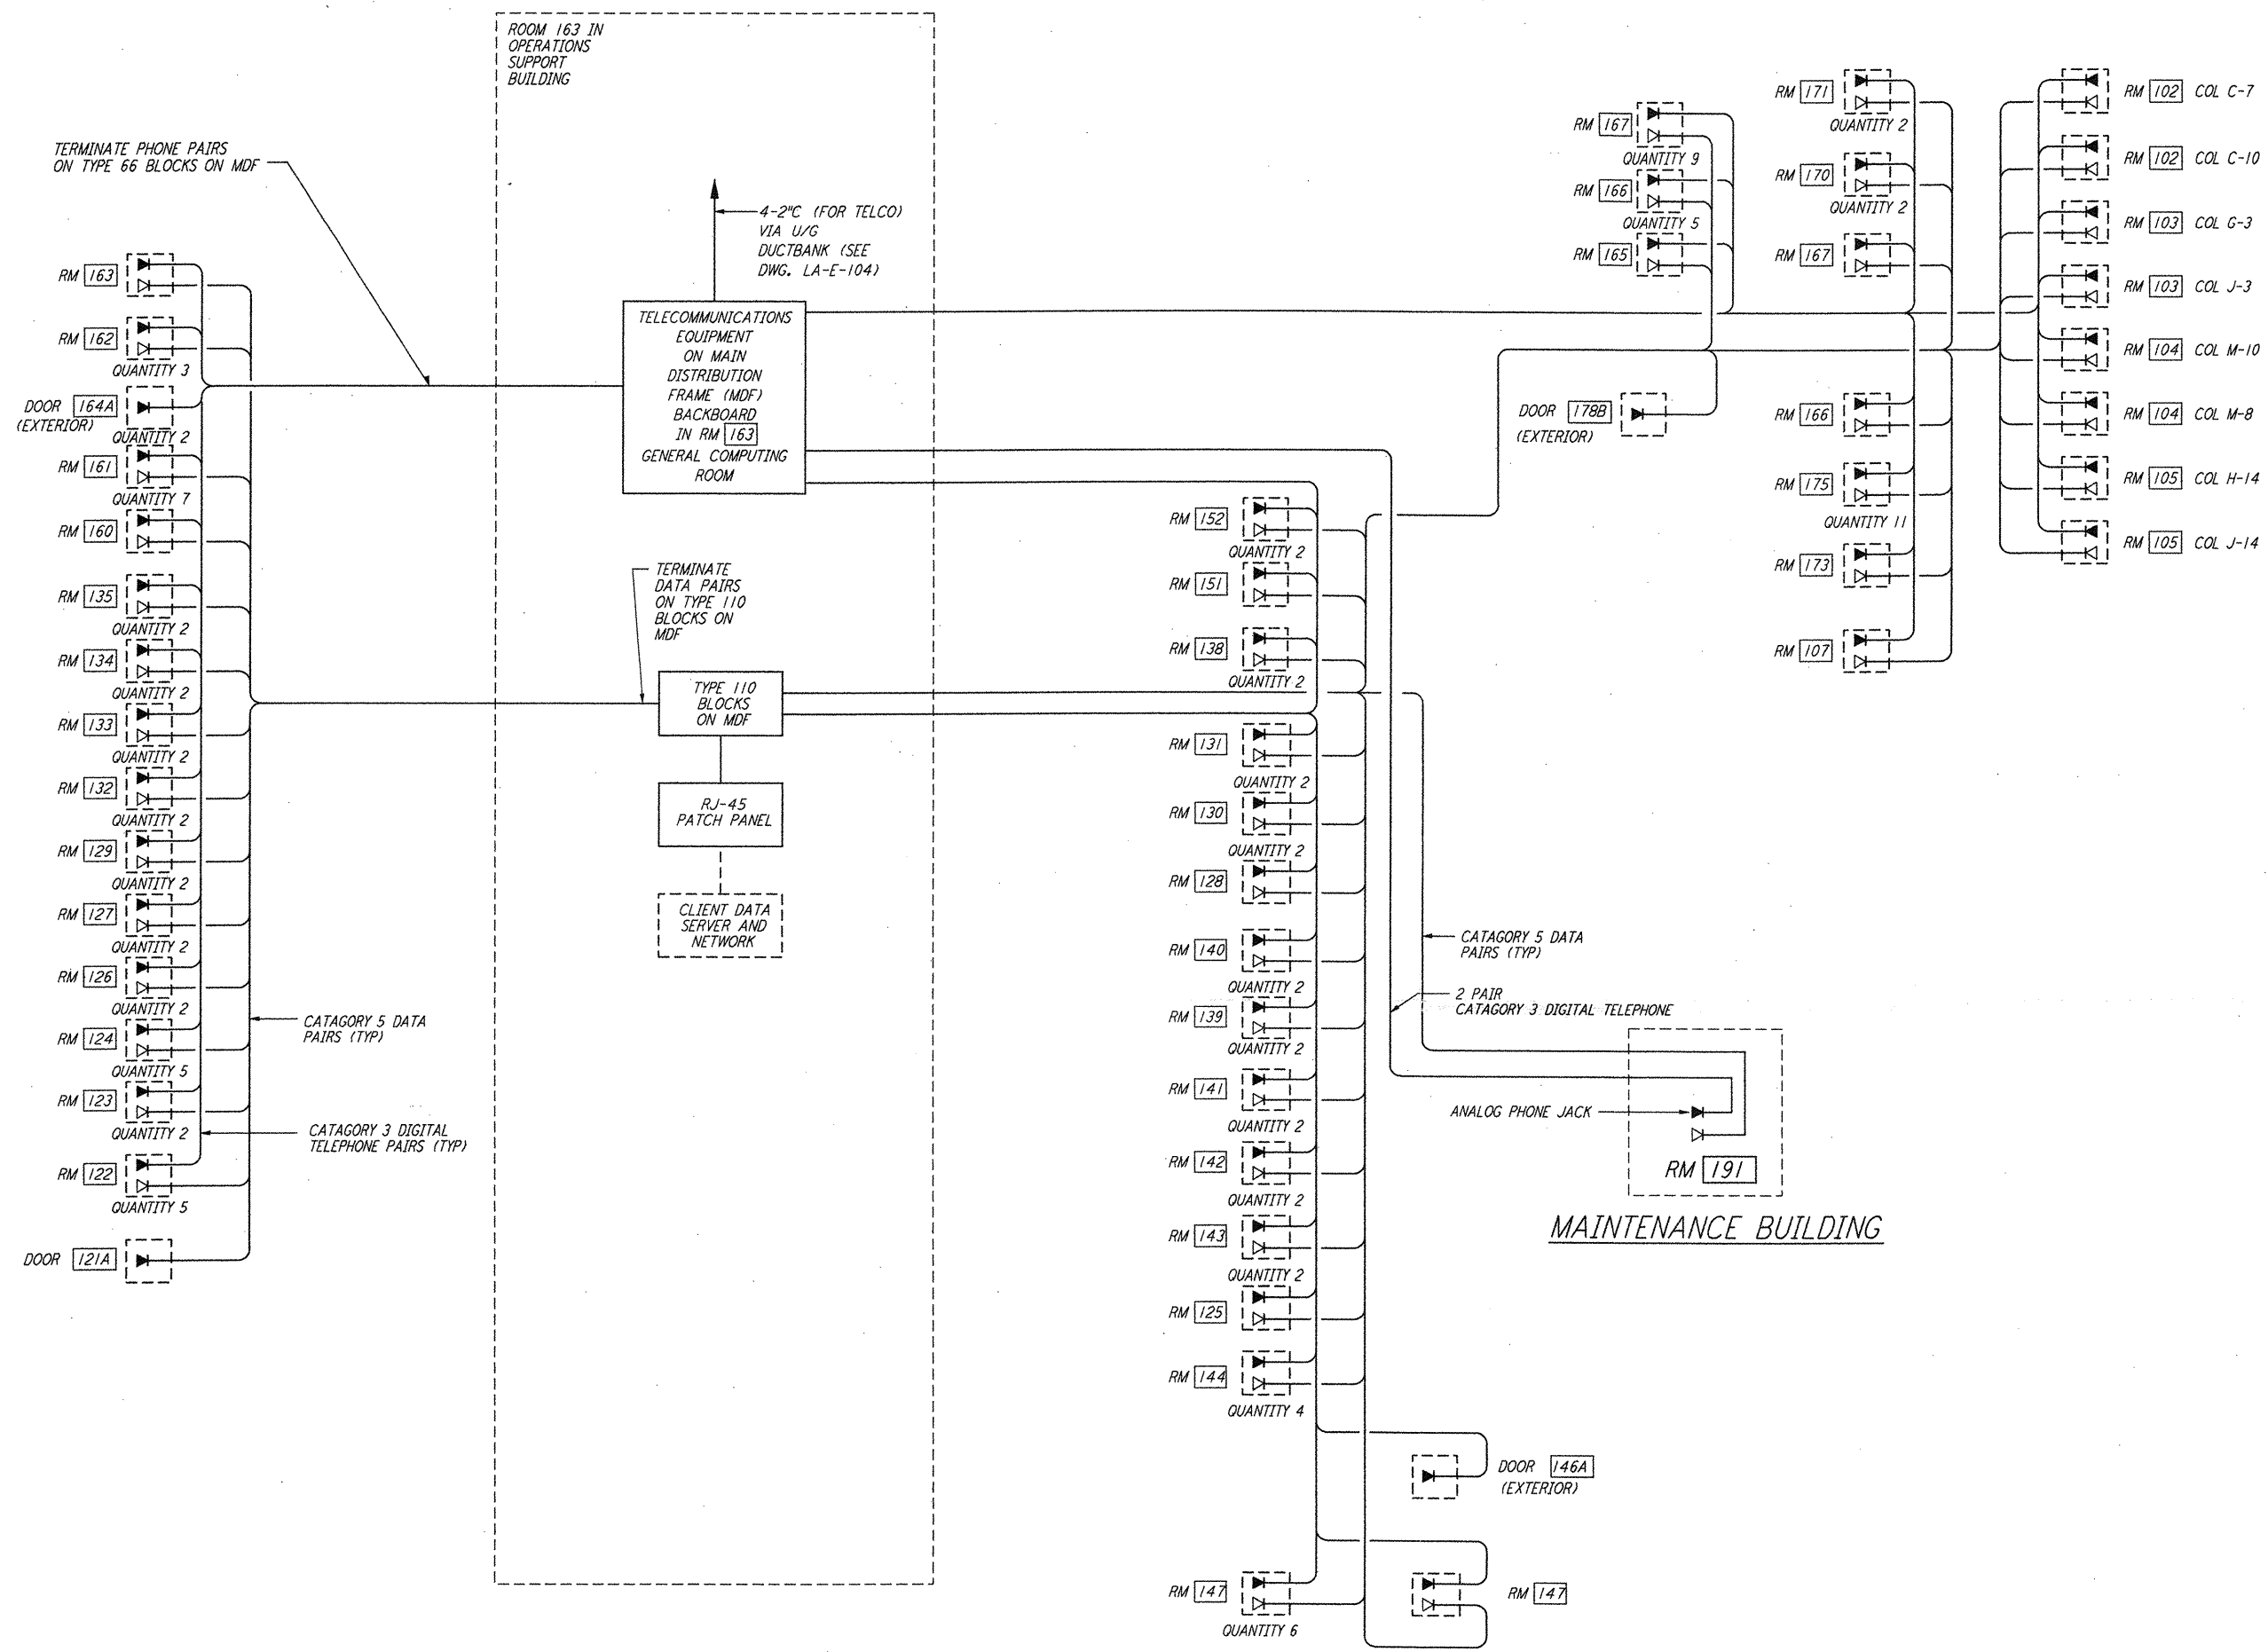

TELEPHONE, FACILITY DATA RISER DIAGRAM

not be reproduced, copied, loaned, exhibited, or used in any other way, except by written consent from PARSONS to the borrower.

This document and the design it covers are the property of PARSONS. They are loaned only with the borrower's expressed written agreement that they will

NO.	DATE	BY	CHKD	ENGR	PROJ	DESCRIPTION
2	6-15-98	J.G.				ISSUED FOR AS-BUILT
1	3-21-97	J.G.	K.R.	K.R.	YDM	GENERAL REVISIONS

ISSUED FOR CONSTRUCTION			
DRAWN	M.M.	6-25-96	
CHECKED	J.K.	7-3-96	
ENGINEER	K.R.	7-3-96	
PROJ	M.D.W.	7-8-96	

AS-BUILT DRAWINGS

PARSONS
 100 WEST WALNUT STREET
 PASADENA, CALIFORNIA

LIGO
 CALIFORNIA INSTITUTE OF TECHNOLOGY
 MASSACHUSETTS INSTITUTE OF TECHNOLOGY

LIGO-D960398-02-O			
LASER INTERFEROMETER GRAVITATIONAL-WAVE OBSERVATORY SITE NO. 1 - HANFORD, WASHINGTON			
TITLE	SCALE	CONTRACT NUMBER	PROJECT NUMBER
ELECTRICAL CORNER STATION COMMUNICATIONS RISER DIAGRAM	NONE	PP150969	8094
SHEET NUMBER		REVISIONS	
WA-E-109			