
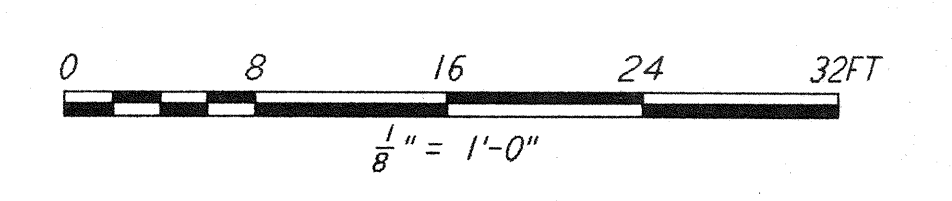


CLEAN AGENT FIRE SUPPRESSION SYSTEM STORAGE CONTAINERS SEE NOTES
 CLEAN AGENT FIRE SUPPRESSION SYSTEM PANEL


- NOTES:**
- A CLEAN AGENT FIRE SUPPRESSION SYSTEM SHALL BE PROVIDED ABOVE AND WITHIN THE DEPRESSED FLOOR SPACE, FOR THE FOLLOWING ROOMS:
 - A. FACILITY CONTROL ROOM [162]
 - B. TAPE & COMPUTER MASS STORAGE ROOM [165]
 - C. COMPUTER USERS ROOM [161]
 - D. GENERAL COMPUTING [163]
 - REFER TO THE PERFORMANCE TYPE SPECIFICATIONS FOR REQUIREMENTS AND DESIGN CRITERIA.

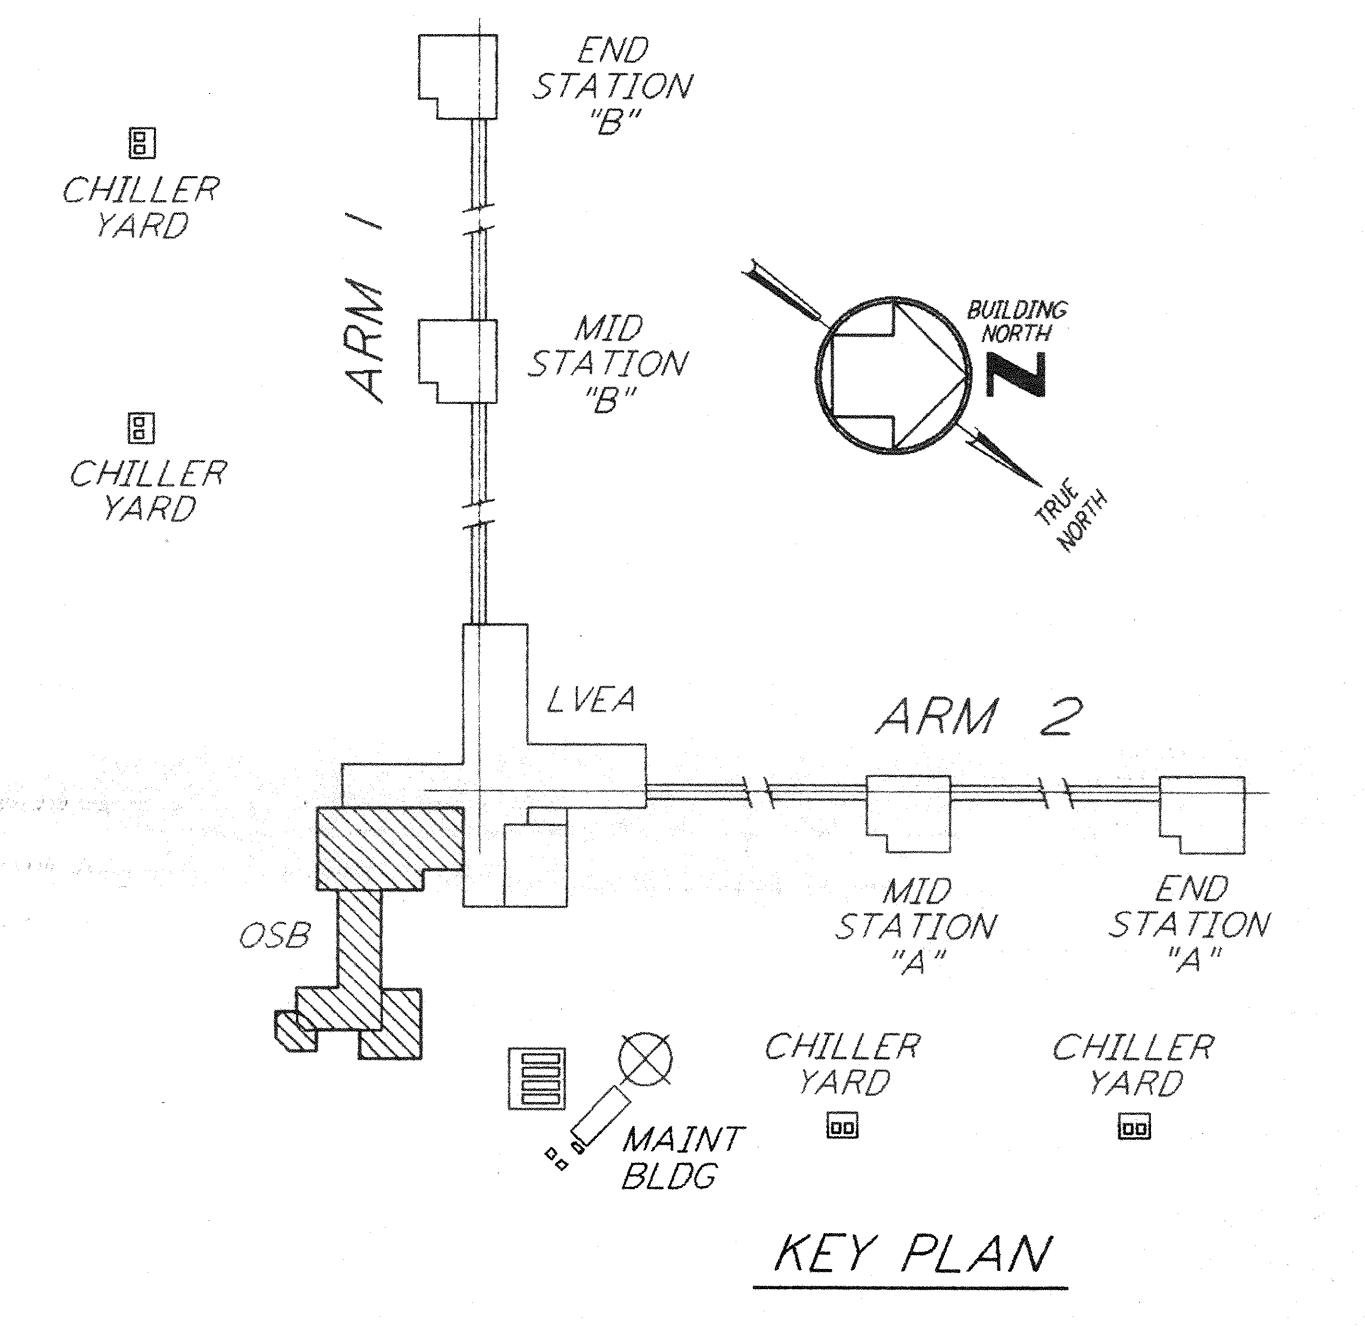

This document and the design it covers are the property of PARSONS. They are loaned only with the borrower's expressed written agreement that they will not be reproduced, copied, loaned, exhibited, or used in any other way, except by written consent from PARSONS to the borrower.

NO.	DATE	BY	CHKD	ENGR	PROJ	DESCRIPTION

ISSUED FOR CONSTRUCTION	
DRAWN	DG 6-24-96
CHECKED	WR 7-9-96
ENGINEER	MW 7-7-96
PROJ	

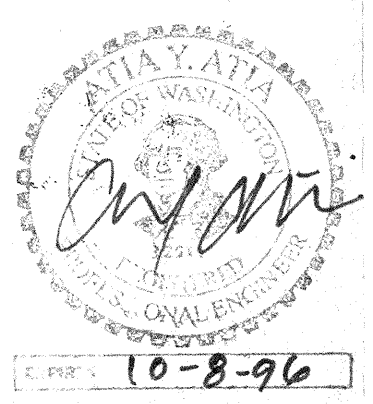

PARSONS
 100 WEST WALNUT STREET
 PASADENA, CALIFORNIA

LIGO
 CALIFORNIA INSTITUTE OF TECHNOLOGY
 MASSACHUSETTS INSTITUTE OF TECHNOLOGY

LASER INTERFEROMETER
 GRAVITATIONAL-WAVE OBSERVATORY
 SITE NO. 1 - HANFORD, WASHINGTON

PLUMBING
 CORNER STATION
 OSB FLOOR PLAN

SCALE: AS NOTED
 SHEET NUMBER: PP150969
WA-P-112

PROJECT NUMBER: 8094
 REVISIONS: