
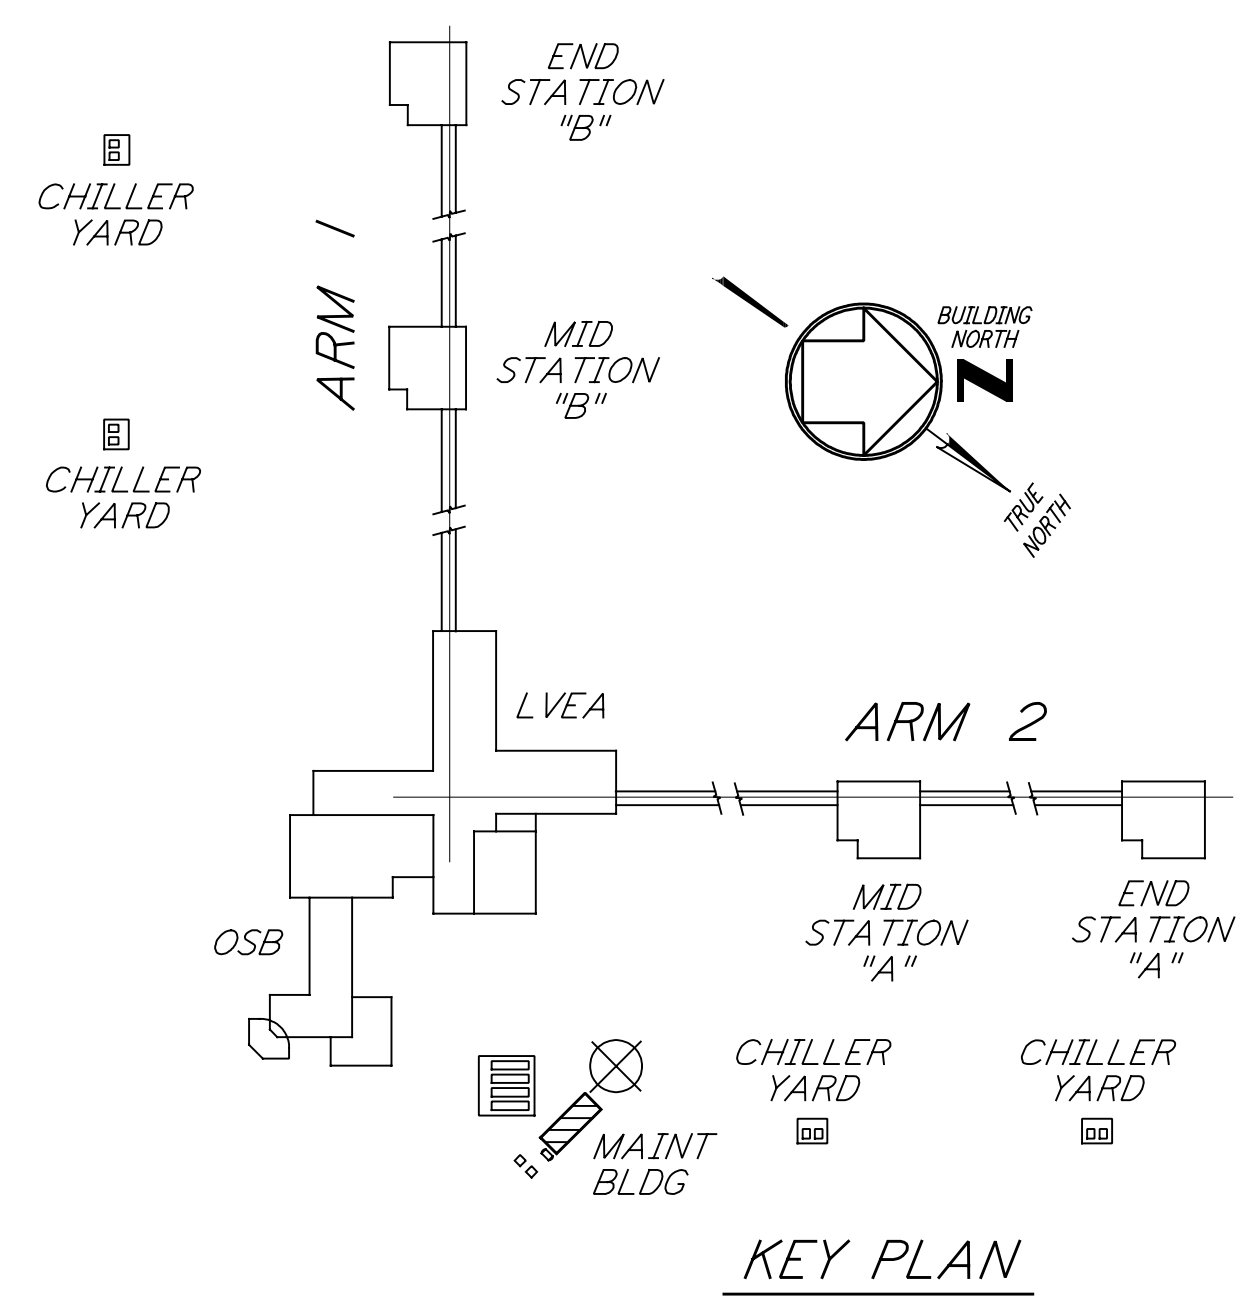


**NOTE:**  
 1. ALL EXTERIOR PIPING SHALL BE HEAT TRACED AND INSULATED.

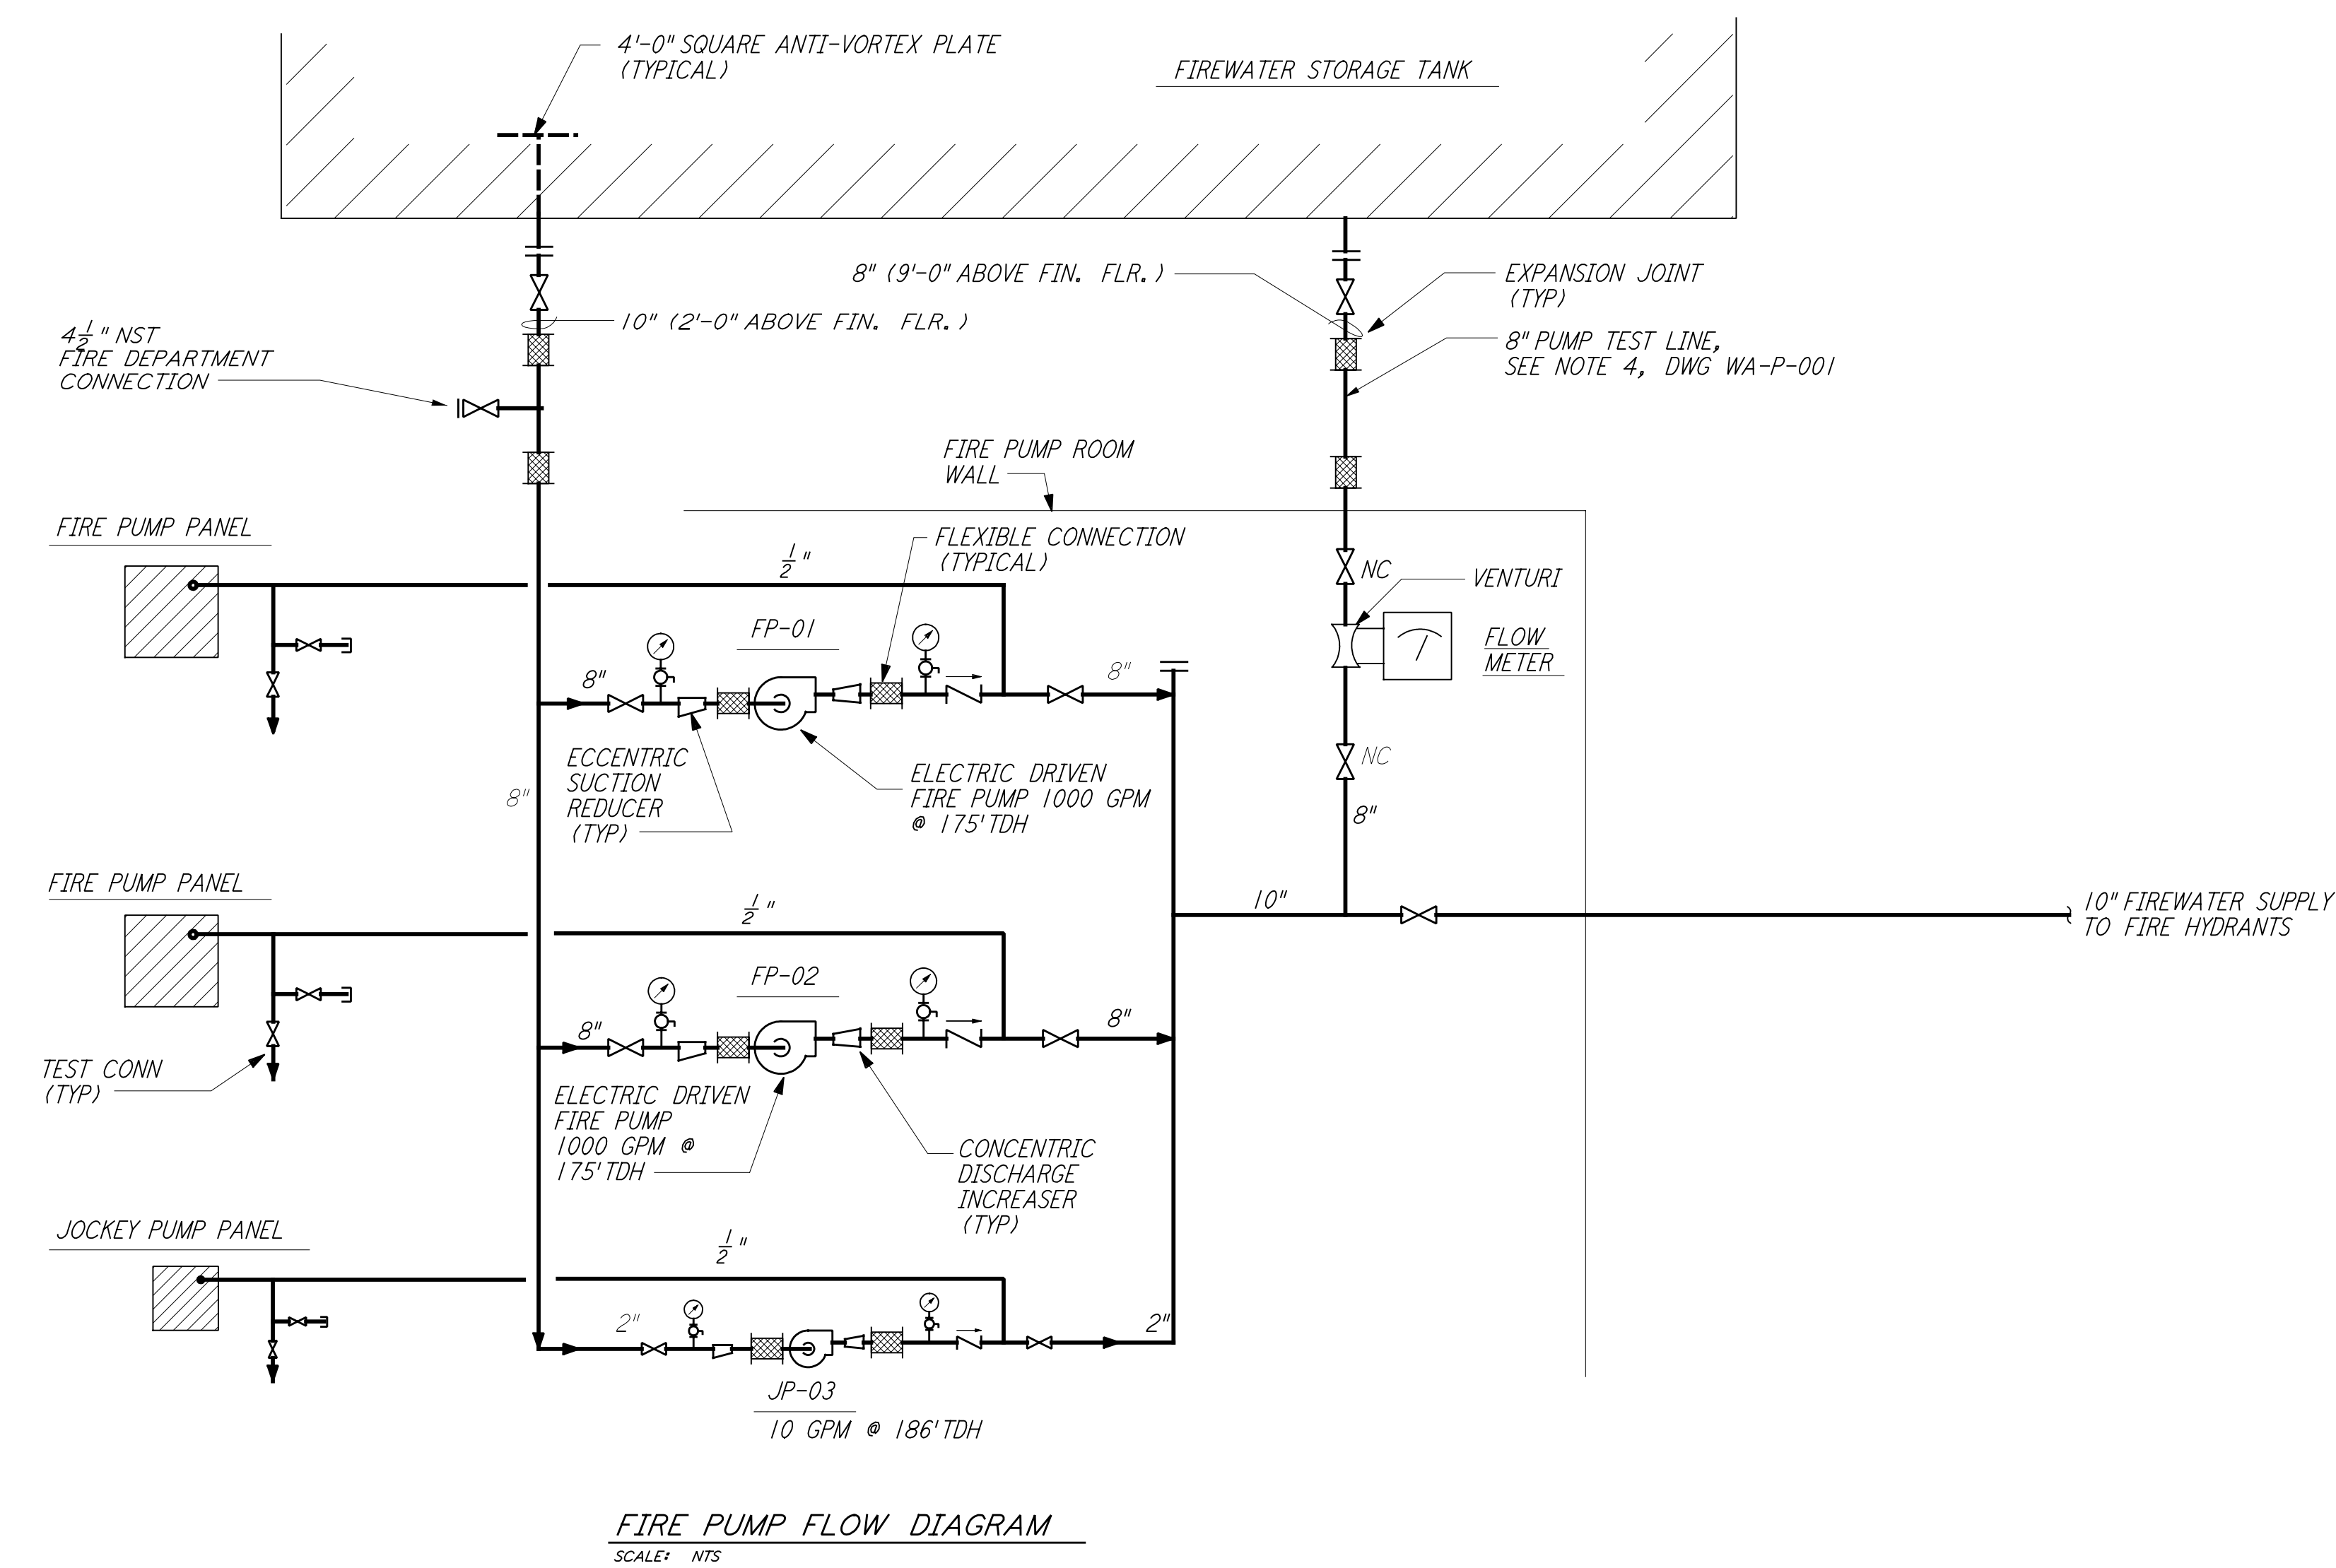

0 4 8 12 16 FT  
 1/4" = 1'-0"

LIGO-D960442-01-0

This document and the design it covers are the property of PARSONS. They are loaned only with the borrower's expressed written agreement that they will not be reproduced, copied, loaned, exhibited, or used in any other way, except by written consent from PARSONS to the borrower.

This document and the design it covers are the property of PARSONS. They are loaned only with the borrower's expressed written agreement that they will not be reproduced, copied, loaned, exhibited, or used in any other way, except by written consent from PARSONS to the borrower.

NO.	DATE	BY	CHKD	ENGR	PROJ	DESCRIPTION
1	5-15-98	CP				ISSUED FOR AS-BUILT

ISSUED FOR CONSTRUCTION	
DRAWN	DG 6-24-96
CHECKED	
ENGINEER	
PROJ	
<b>AS-BUILT DRAWINGS</b>	



LASER INTERFEROMETER  
 GRAVITATIONAL-WAVE OBSERVATORY  
 SITE NO. I - HANFORD, WASHINGTON

TITLE	PLUMBING CORNER STATION MAINTENANCE BUILDING FLOOR PLAN & FLOW DIAGRAM	AS NOTED	PP150969	8094
SHEET NUMBER	WA-P-113	PROJECT NUMBER		