
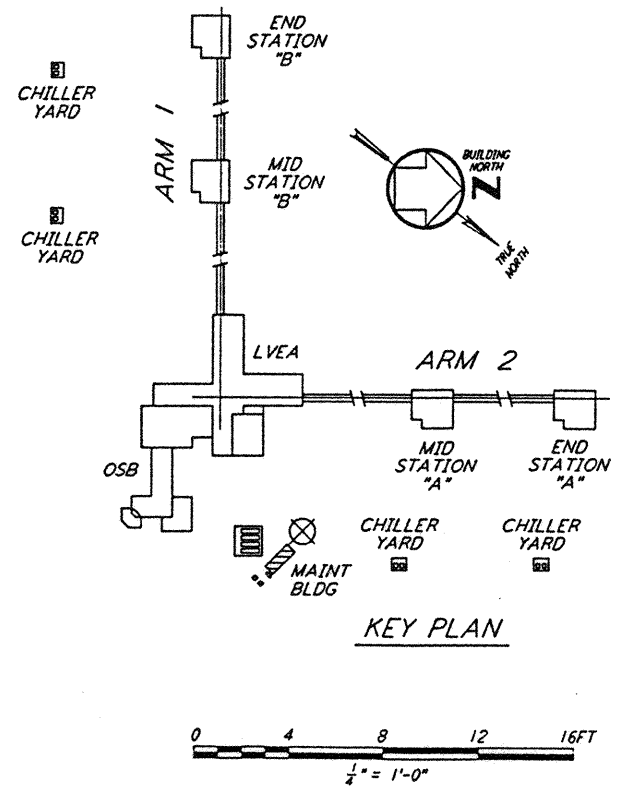


NOTE:
1. ALL EXTERIOR PIPING SHALL BE HEAT TRACED AND INSULATED.

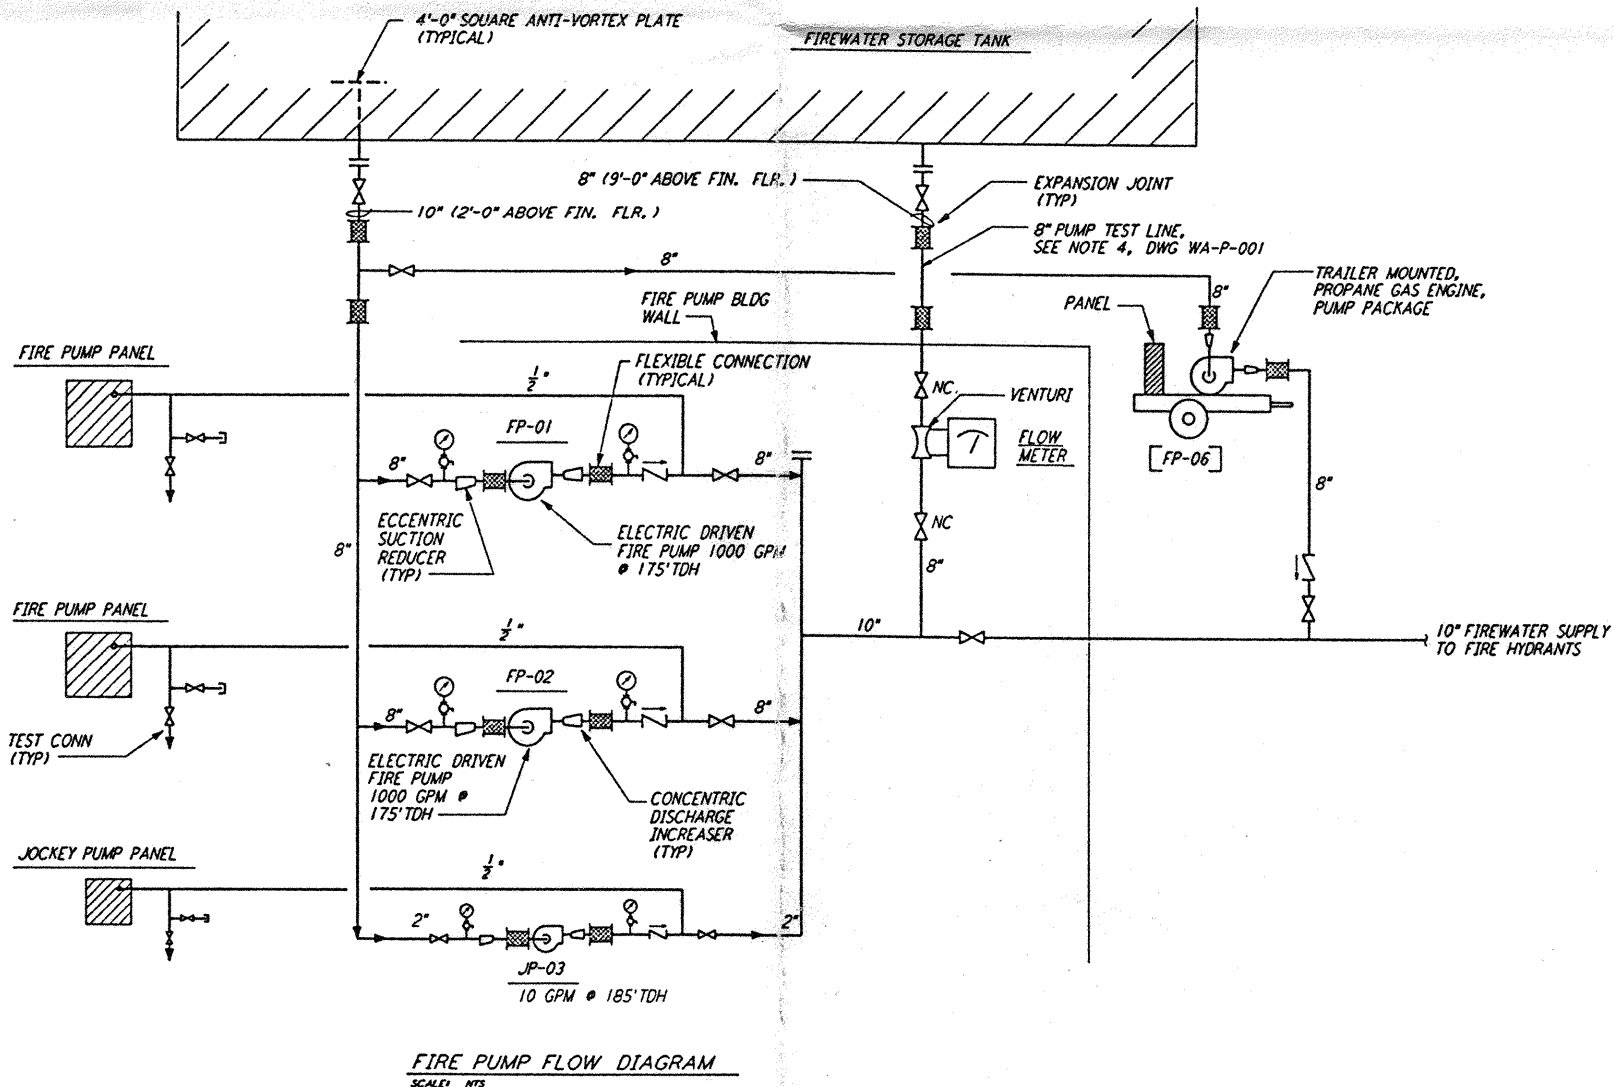

REFERENCES		REVISIONS										DRAWN		CHECKED		ENGINEER		PROJ	
DRAWING NO.	DESCRIPTION	NO.	DATE	BY	CHKD	ENGR	PROJ	DESCRIPTION											
		B	4-19-96	DG	MP	MN		FINAL DESIGN REVIEW & BID											
		A	10-31-95	SG	MP	MN	TDM	PRELIMINARY DESIGN REVIEW											

PARSONS
100 WEST WALNUT STREET
PASADENA, CALIFORNIA

LIGO
CALIFORNIA INSTITUTE OF TECHNOLOGY
MASSACHUSETTS INSTITUTE OF TECHNOLOGY

LASER INTERFEROMETER
GRAVITATIONAL-WAVE OBSERVATORY
SITE NO. 1 - HANFORD, WASHINGTON

TITLE	PLUMBING CORNER STATION MAINTENANCE BUILDING FLOOR PLAN & FLOW DIAGRAM	SCALE	AS NOTED	CONTRACT NUMBER	PP150969	PROJECT NUMBER	8094
SHEET NUMBER	WA-P-113			REVISIONS			

LIGO-D960441-B-D

LIGOWAF3.BOR