



MATCHLINE SEE DWG. V049-3-102

NOTES:

- 1) FOR GENERAL NOTES & LEGEND SEE PSI DWG. #V049-3-001 SHT. 1.
- 2) FOR LIST OF CIVIL CONTRACTOR REFERENCE DWGS. WITH CURRENT REVISIONS SEE PSI DWG. #V049-3-001 SHT. 2.
- 3) FOR INSTRUMENT INSTALLATION DETAILS SEE PSI DWG. #V049-3-008.

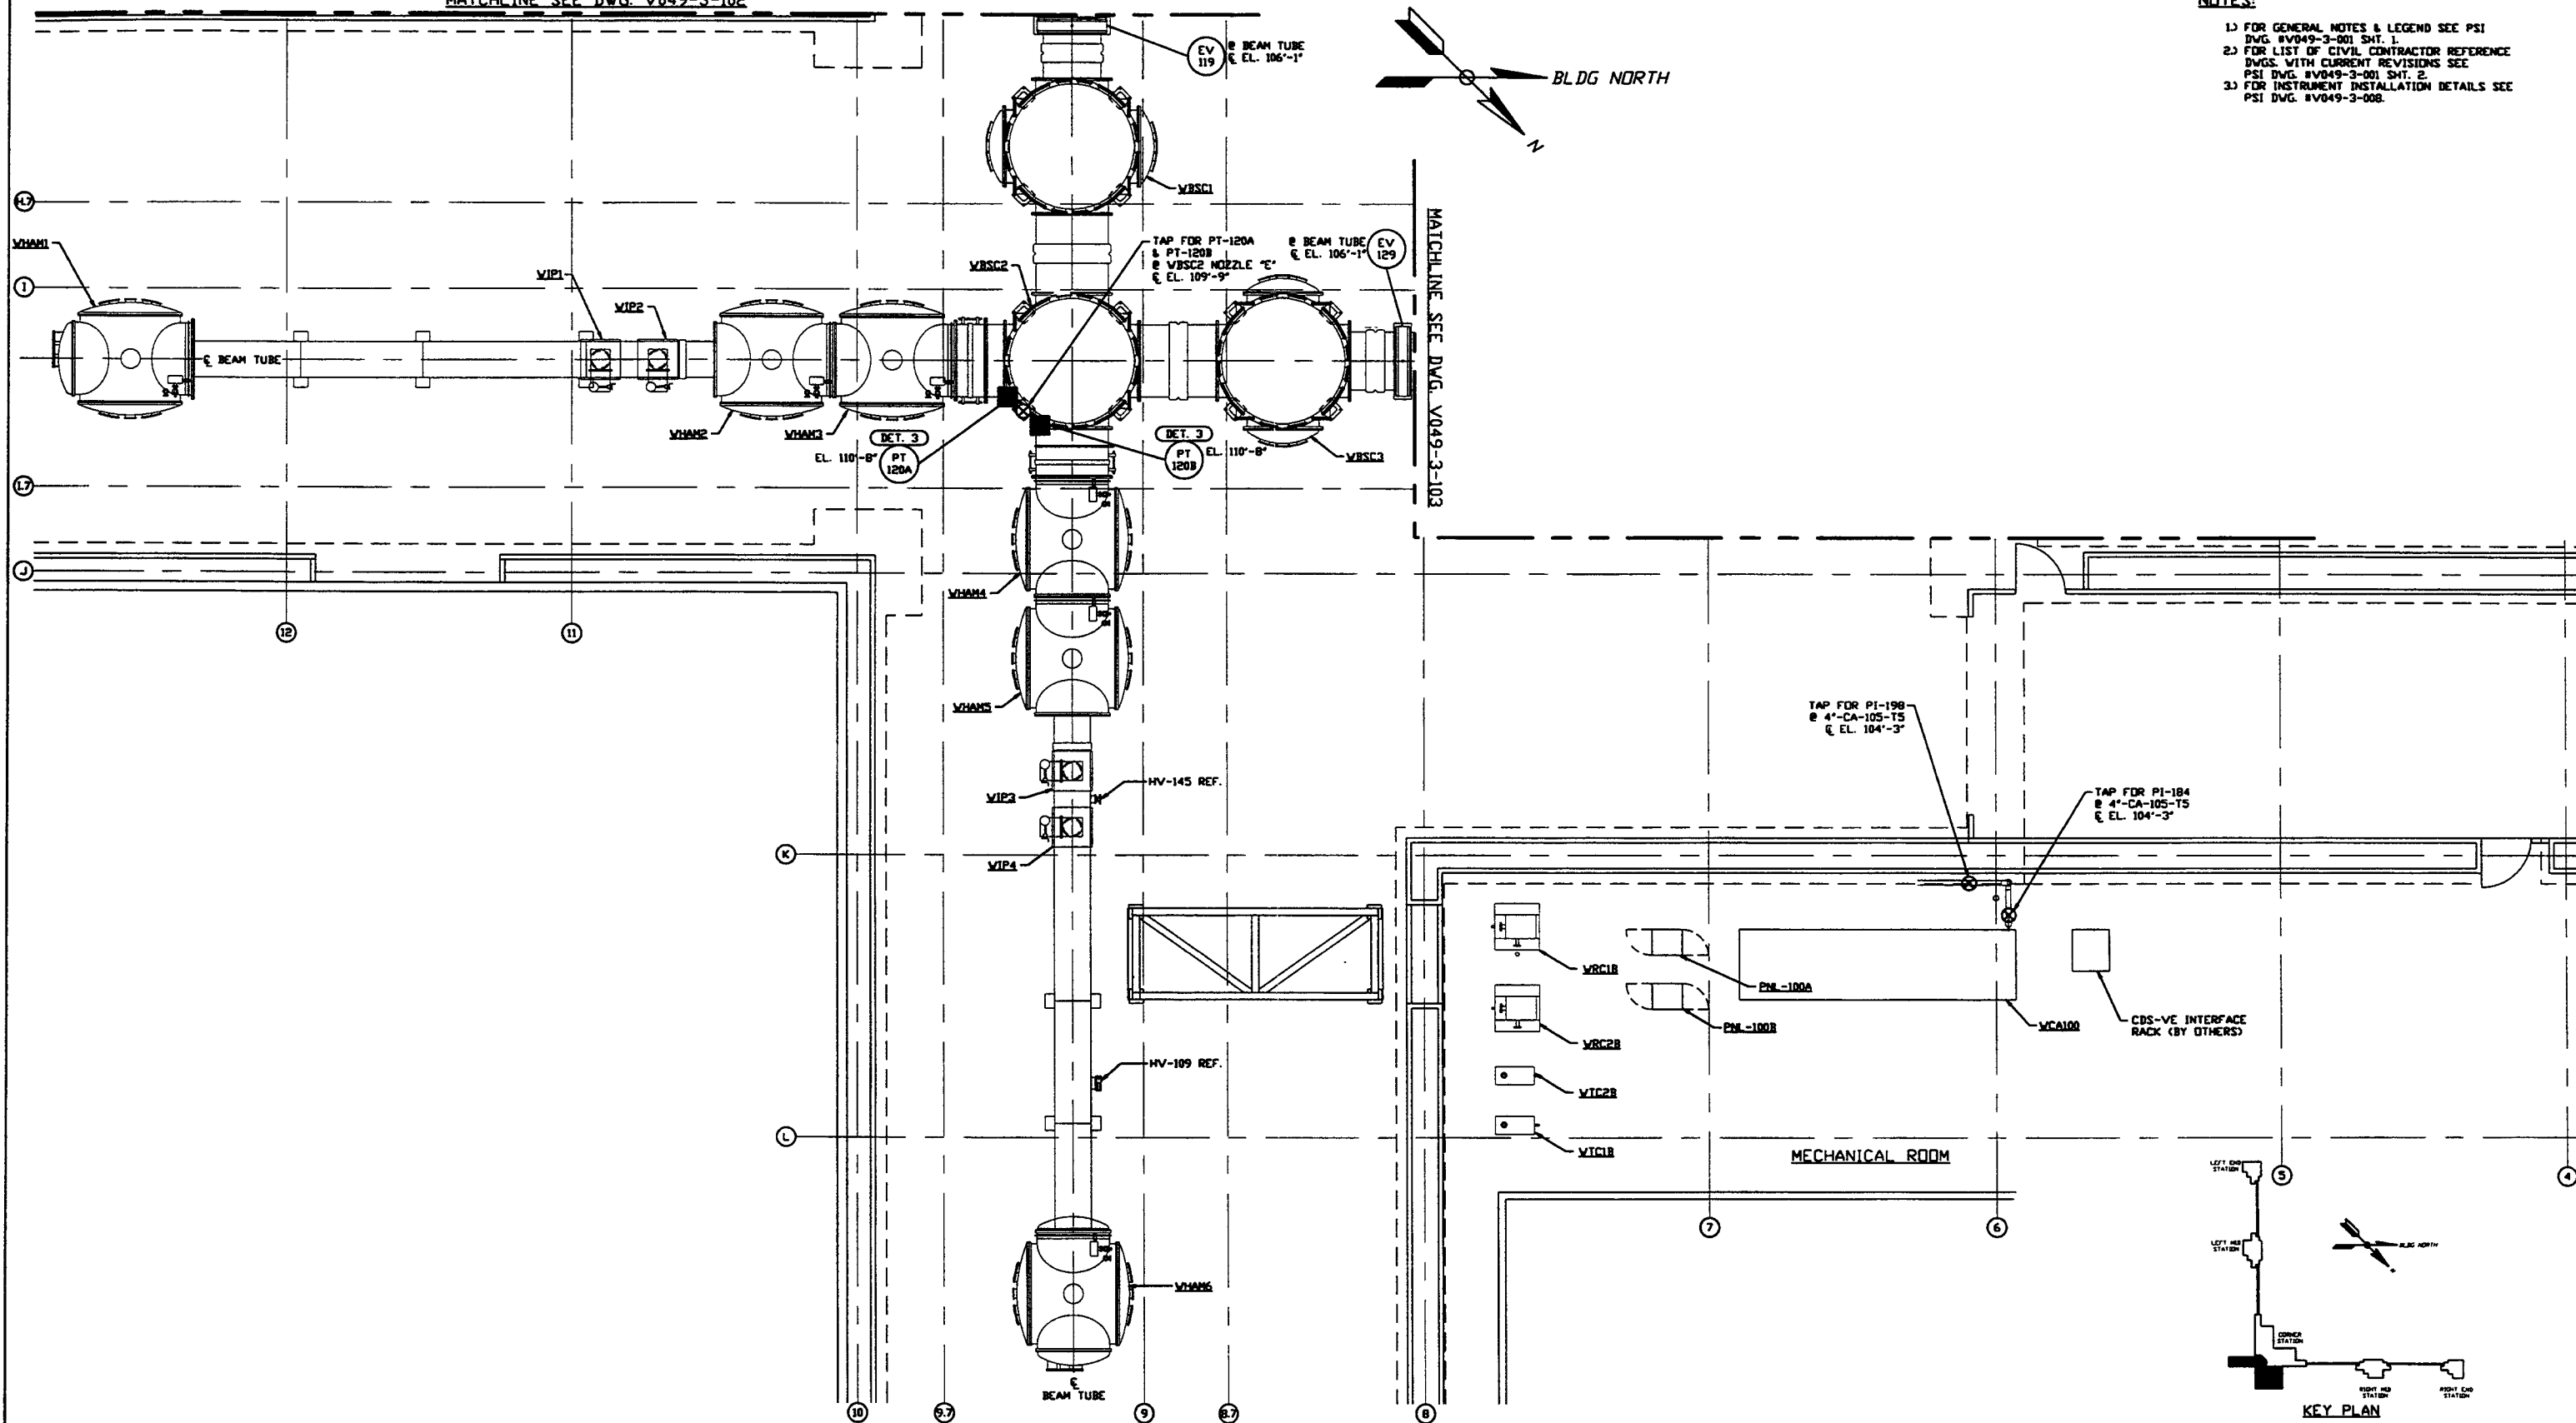

VERTEX SECTION PLAN @ EL. 100'-0"

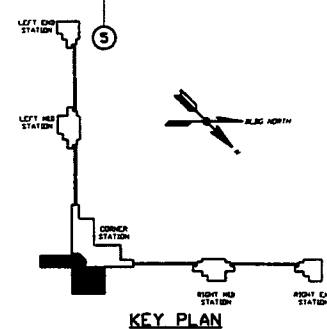

KEY PLAN

DWG. NO.	DESCRIPTION	DWG. NO.	DESCRIPTION
V049-3-103	INSTRUMENT PLAN WASHINGTON RIGHT BEAM MANIFOLD		
V049-3-102	INSTRUMENT PLAN WASHINGTON LEFT BEAM MANIFOLD		
V049-3-008	INSTRUMENT INSTALLATION DETAILS		
V049-3-002	WASHINGTON OVERALL SITE PLAN		
V049-3-001	GENERAL NOTES & LEGEND	V049-5-012	PIPING PLAN WASHINGTON CORNER STATION
V049-0-013	P & I D WASHINGTON VERTEX SECTION	V049-5-001	EQUIP. ARRANGEMENT WASHINGTON CORNER STATION

REV	DESCRIPTION	CHKD	DRWN	DATE	DEDR
2	ISSUE FOR CONSTRUCTION			05.12.97	0480
1	ISSUE FOR FDR UPDATE & BID			11.25.96	0355
0	ISSUE FOR FDR			04.26.96	0129

UNLESS OTHERWISE SPECIFIED	UNLESS OTHERWISE SPECIFIED	UNLESS OTHERWISE SPECIFIED	UNLESS OTHERWISE SPECIFIED	UNLESS OTHERWISE SPECIFIED	UNLESS OTHERWISE SPECIFIED
INCHES	INCHES	INCHES	INCHES	INCHES	INCHES
FUNCTIONAL	FUNCTIONAL	FUNCTIONAL	FUNCTIONAL	FUNCTIONAL	FUNCTIONAL
2	2	2	2	2	2
1	1	1	1	1	1
0	0	0	0	0	0

PROCESS SYSTEMS INTERNATIONAL INC.
 20 WALKUP DR. WESTBOROUGH, MASSACHUSETTS 01581 USA

INSTRUMENT PLAN
LIGO VACUUM EQUIPMENT
WASHINGTON SITE
VERTEX SECTION

CAD FILE: V0493101
 SIZE: D
 DWG. NO.: V049-3-101
 REV: 2

SCALE: 3/16" = 1' - 0"
 SHEET: 1 OF 1