




Mon Jul 22 17:18:18 1996 S3-V18B2 J:\PLOTS\NOUES\18B2\ST103.PRF

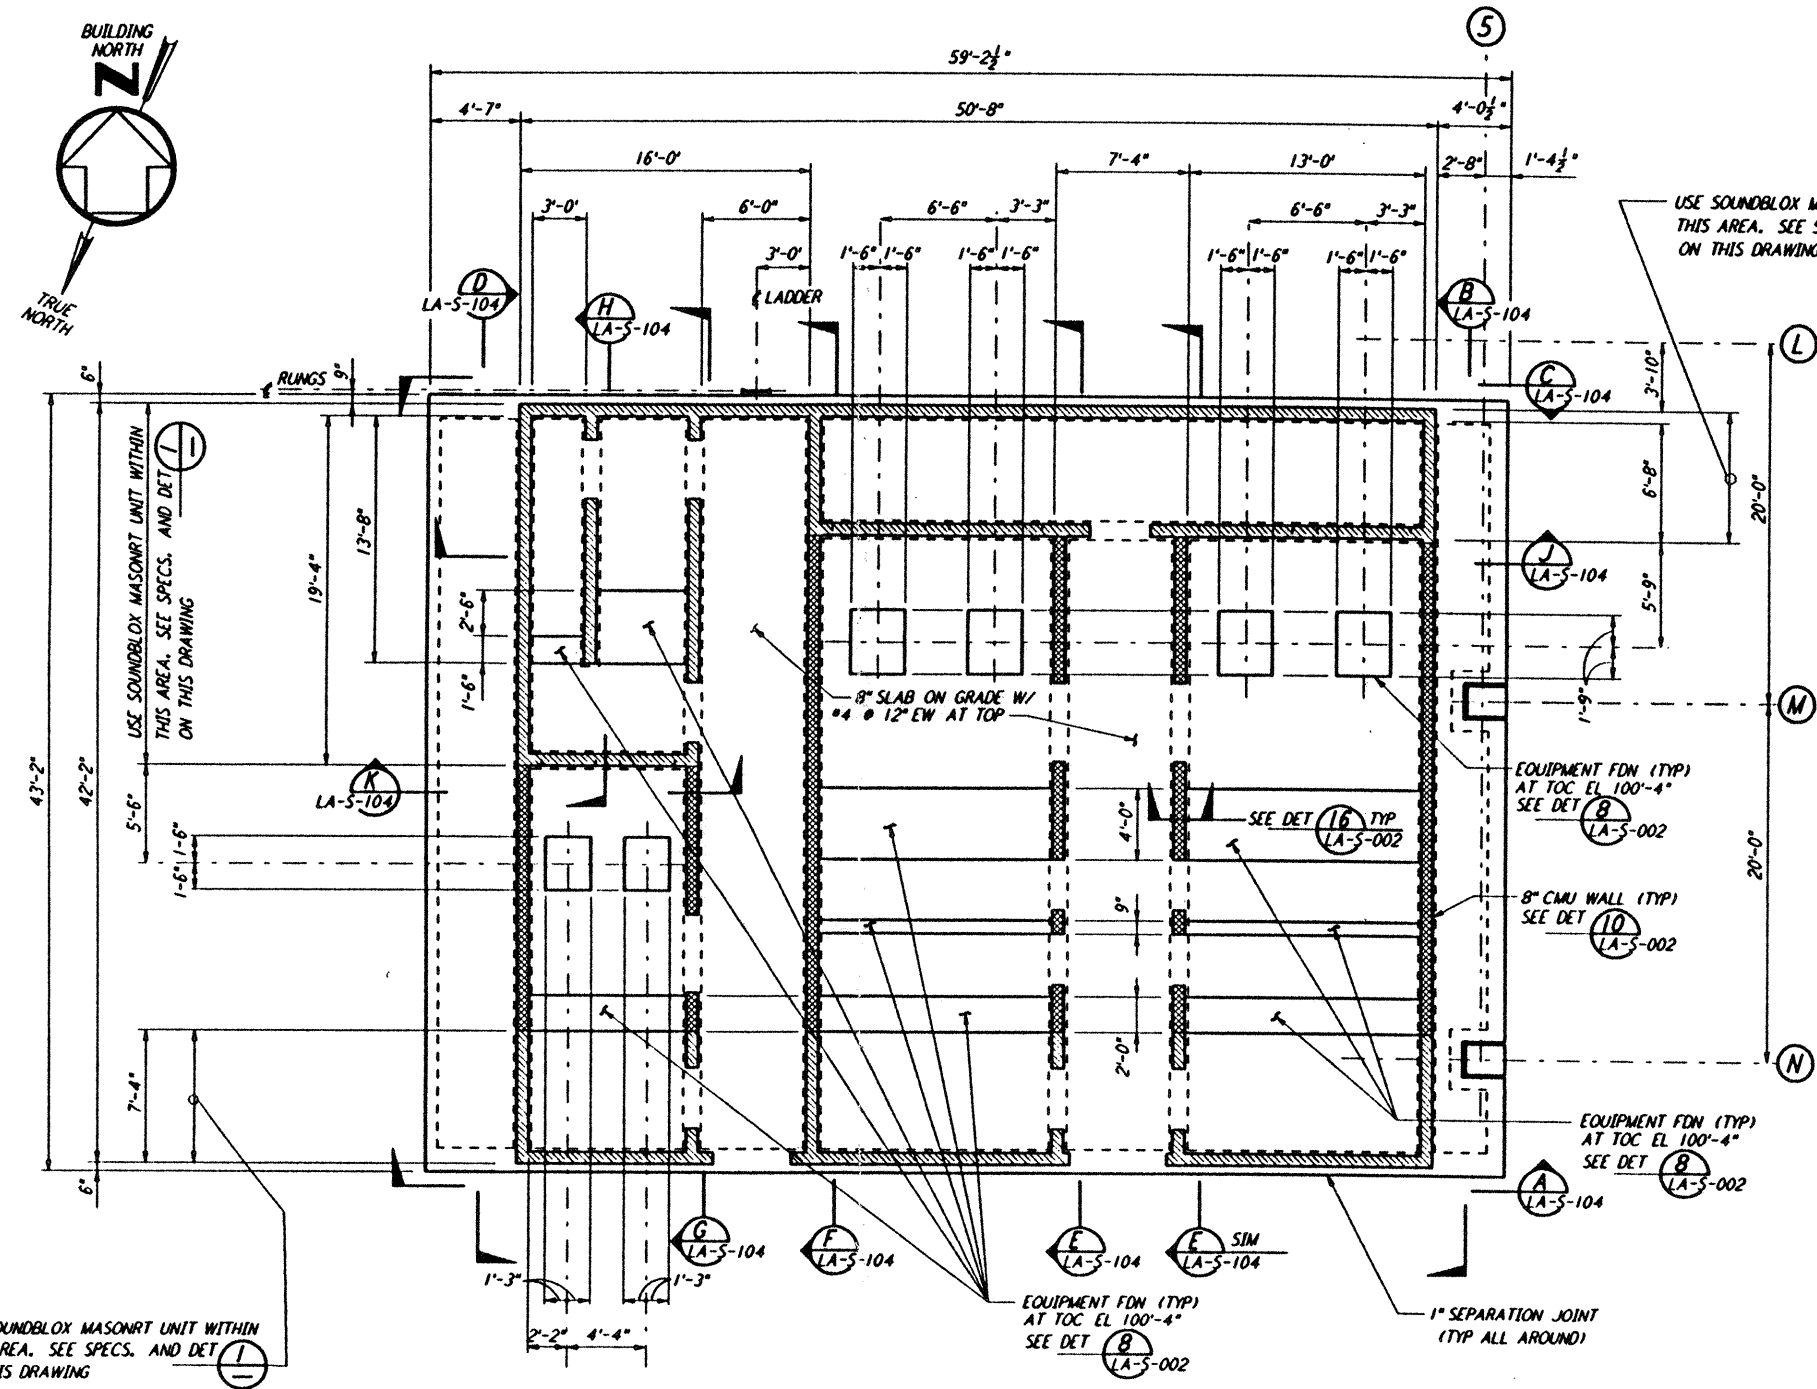


**AIR HANDLING UNIT STRUCTURE  
 FOUNDATION PLAN**  
 1/4" = 1'-0"

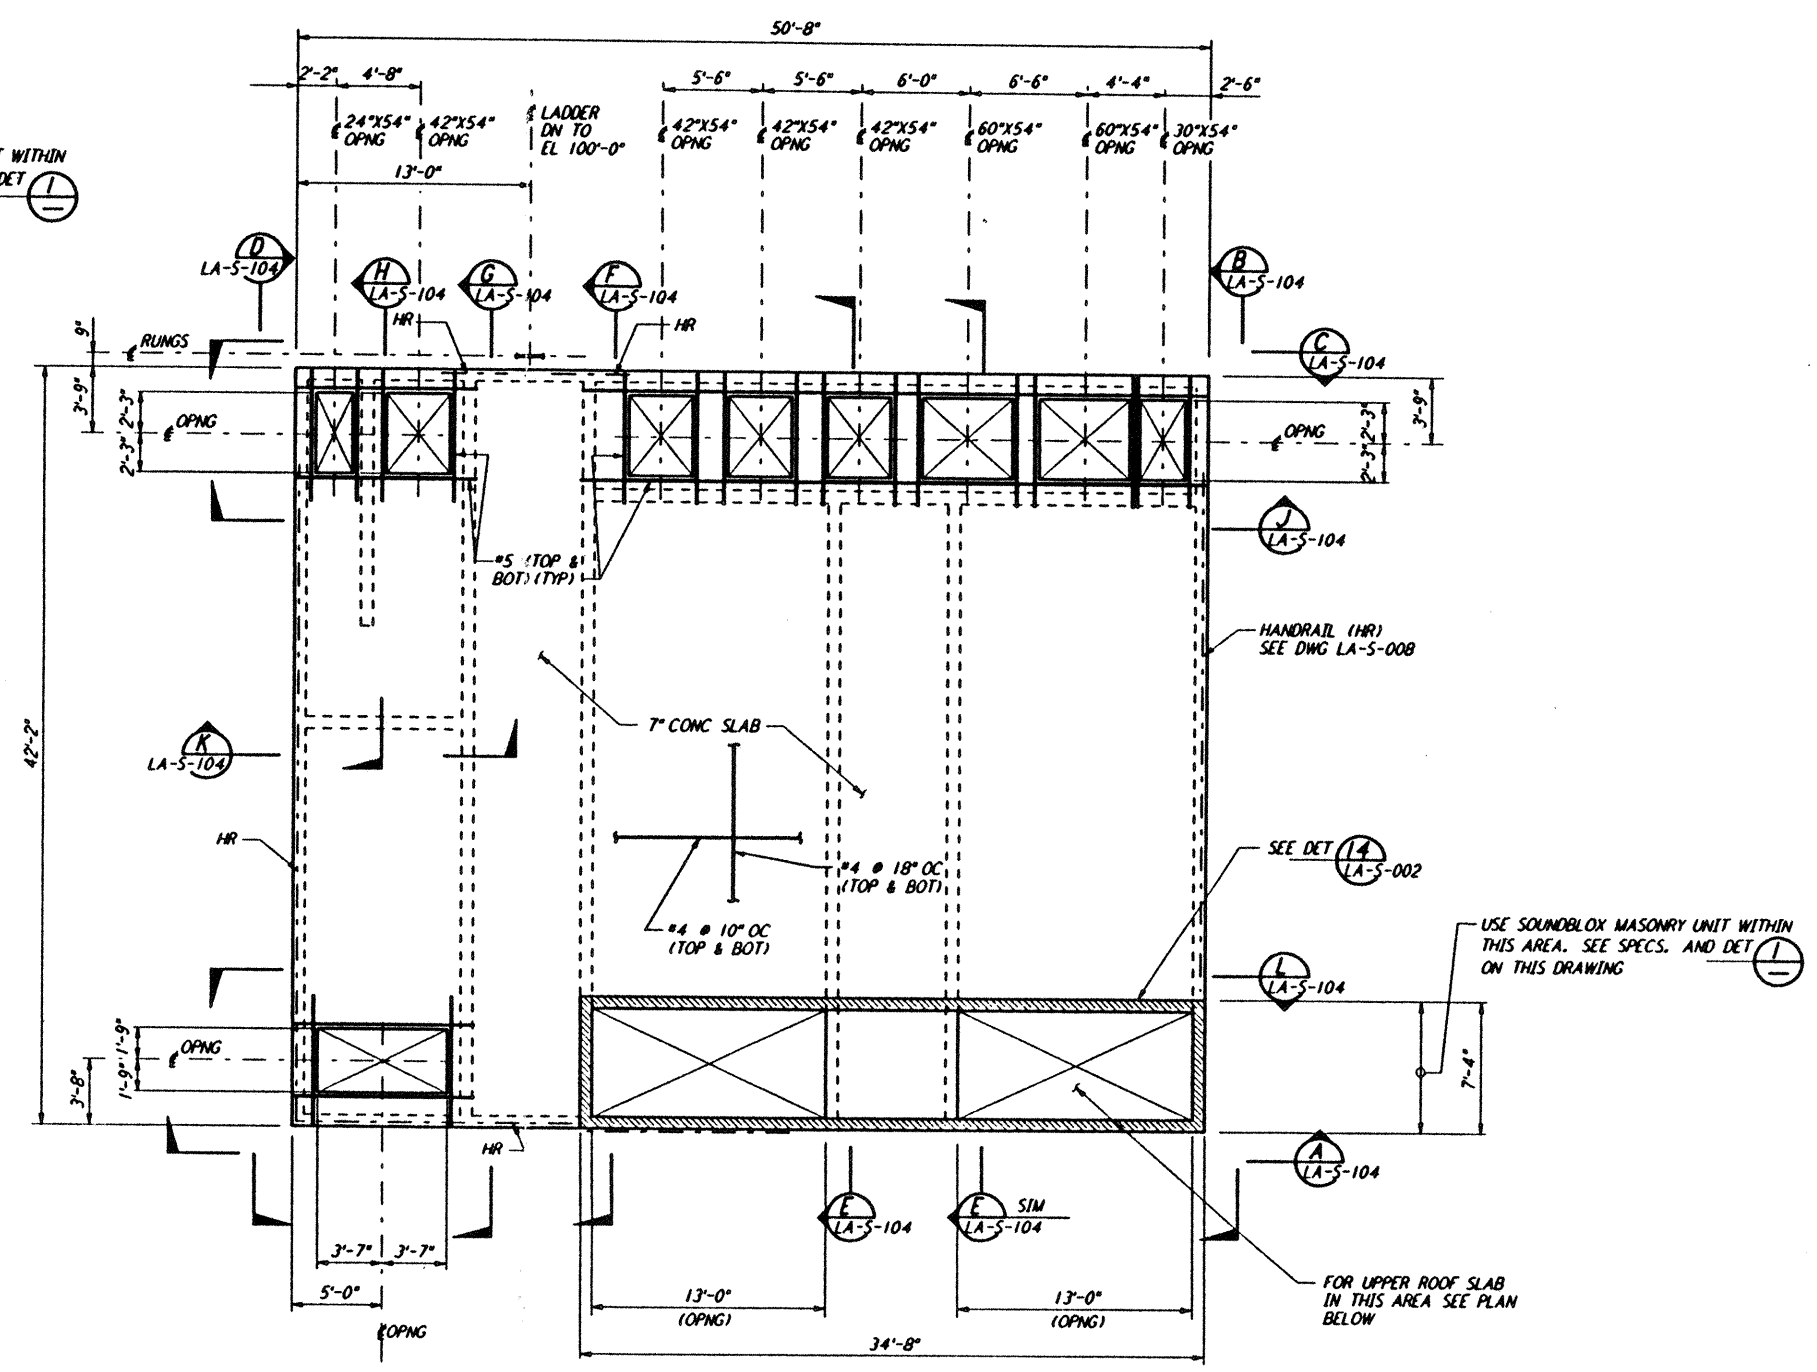

**AIR HANDLING UNIT STRUCTURE  
 LOWER CONCRETE ROOF SLAB PLAN**  
 1/4" = 1'-0"  
 TOC EL 110'-7"

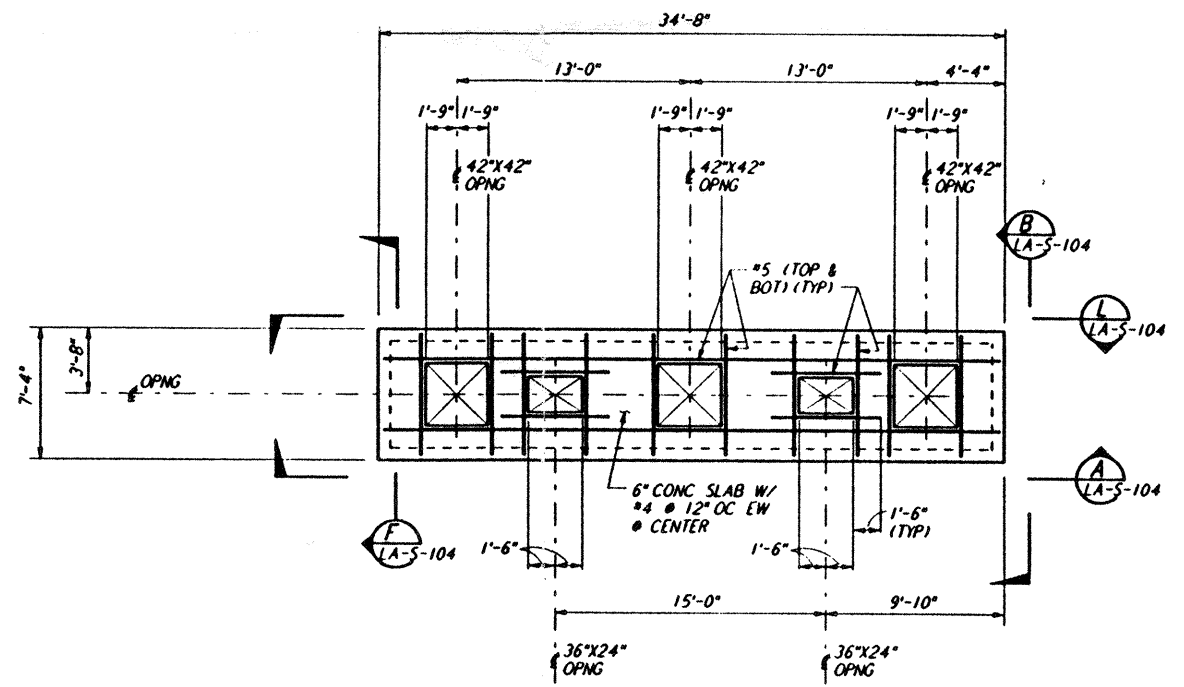


**AIR HANDLING UNIT STRUCTURE  
 UPPER CONCRETE ROOF SLAB PLAN**  
 1/4" = 1'-0"  
 TOC EL 115'-2"

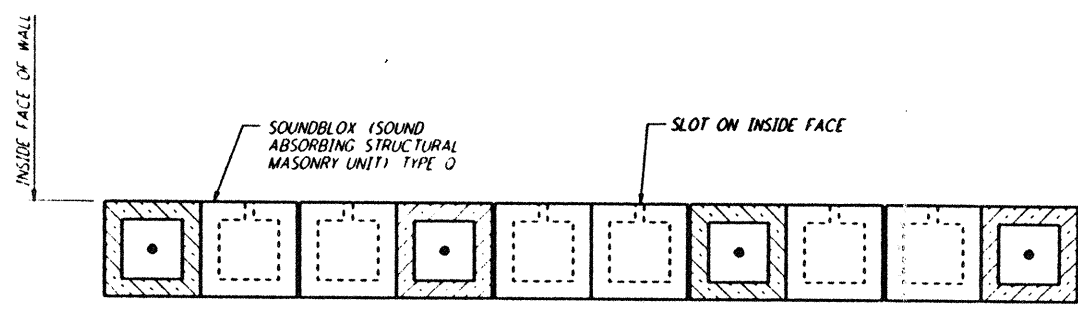

**TYPICAL SECTION OF SOUNDBLOX MASONRY WALL  
 DETAIL**  
 1/2" = 1'-0"

 - NOTES:**
- FOR GENERAL NOTES, ABBREVIATIONS & SYMBOLS SEE DRAWING LA-S-001.
  - CONTRACTOR SHALL ADJUST LOCATION AND SIZE OF ALL EQUIPMENT PADS TO SUIT ACTUAL VENDOR EQUIPMENTS.



This document and the design it covers are the property of PARSONS. They are loaned only with the borrower's expressed written agreement that they will not be reproduced, copied, loaned, exhibited, or used in any other way, except by written consent from PARSONS to the borrower.

NO.	DATE	BY	CHK'D	ENGR	PROJ	DESCRIPTION
B	7-24-96	MCS	DDM	BP	TOM	ISSUED FOR BID
A	6-14-96	MCS	DDM	BP	TOM	FINAL DESIGN REVIEW

DRAWN	MCS
CHECKED	
ENGINEER	
PROJ	

**PARSONS**  
 100 WEST WALNUT STREET  
 PASADENA, CALIFORNIA

**LIGO**  
 CALIFORNIA INSTITUTE OF TECHNOLOGY  
 MASSACHUSETTS INSTITUTE OF TECHNOLOGY

**LASER INTERFEROMETER  
 GRAVITATIONAL-WAVE OBSERVATORY  
 SITE NO. 2 - LIVINGSTON, LOUISIANA**

TITLE	SCALE	CONTRACT NUMBER	PROJECT NUMBER
STRUCTURAL CORNER STATION AIR HANDLING UNIT ENCLOSURE PLAN	AS NOTED	PP150969	8094
PROJECT NUMBER		DRAWING NUMBER	
LA-S-103		A	