
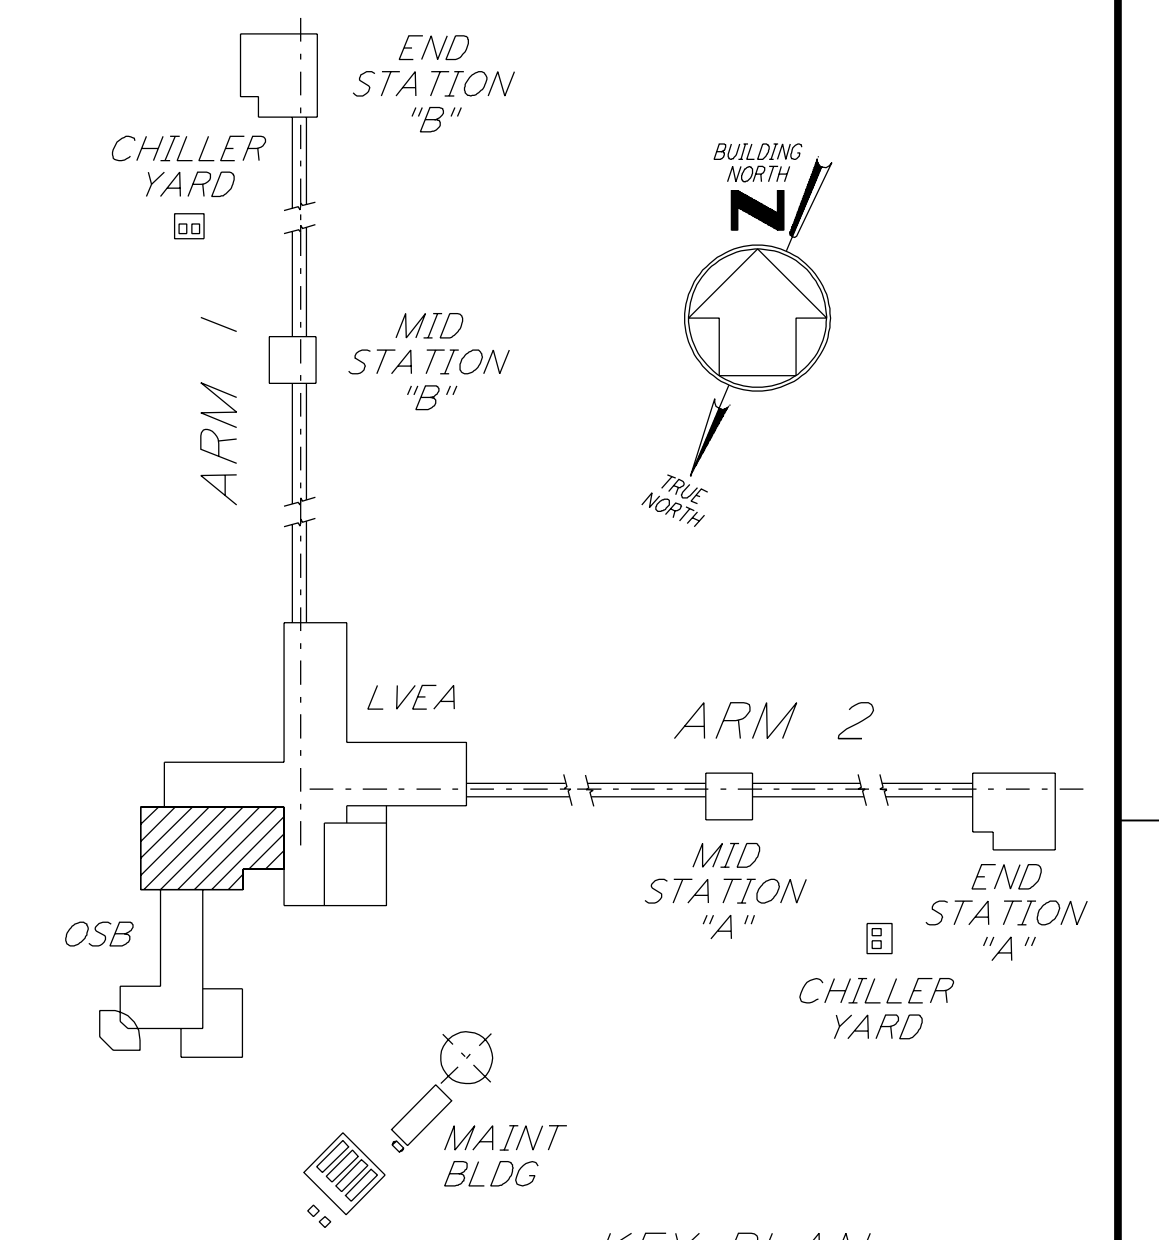
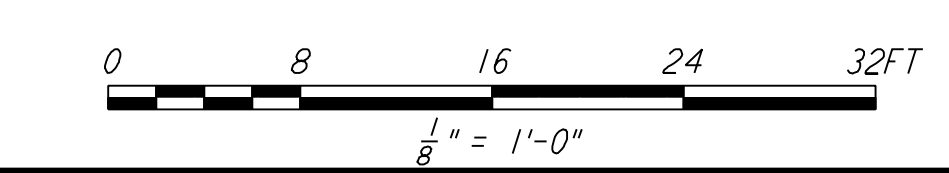
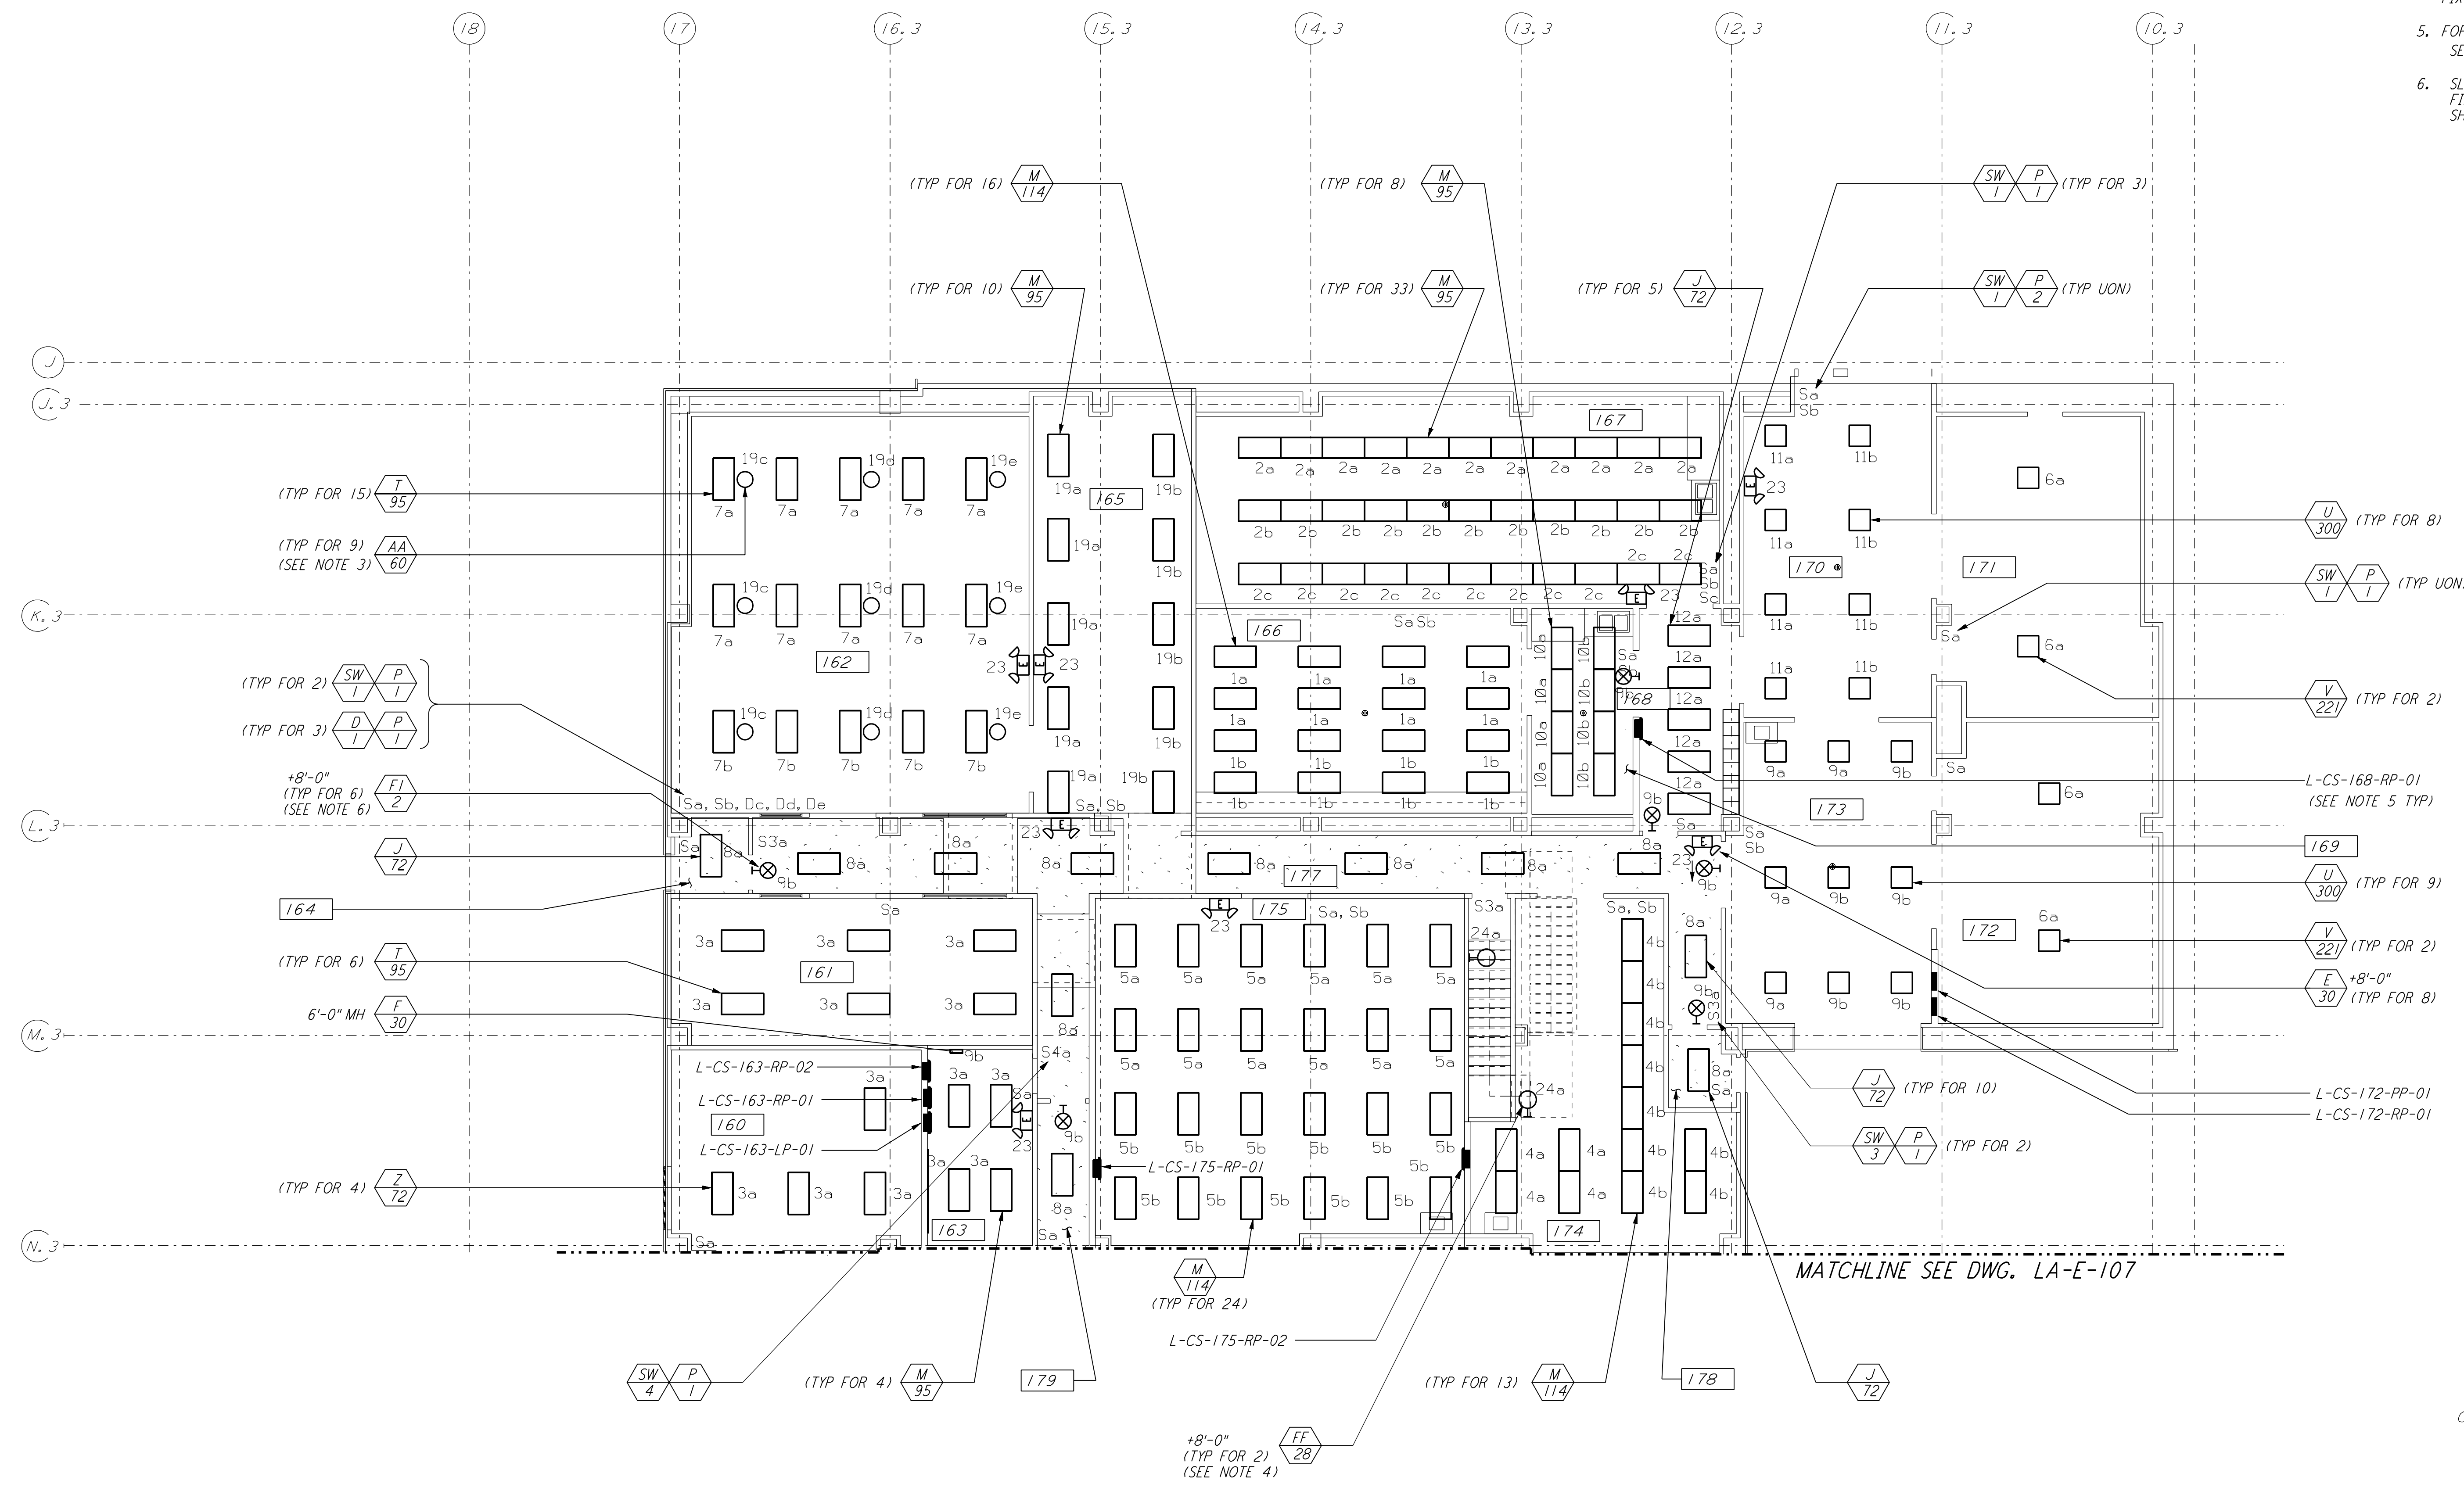


**NOTES:**

- FOR NOTES AND REFERENCE DRAWINGS SEE DWG. LA-E-107.
- ALL LIGHTING CIRCUITS SHOWN ON THIS DRAWING ARE FROM PANEL L-CS-163-LP-01 UNLESS NOTED OTHERWISE.
- CIRCUIT SHOWN FEEDING THESE LIGHTING FIXTURES IS FROM L-CS-163-RP-01.
- CIRCUIT SHOWN FEEDING THESE LIGHTING FIXTURES IS FROM L-CS-168-RP-01.
- FOR ALL PANEL FEEDER CONDUIT AND WIRE SIZES SEE SINGLE LINE DIAGRAM DWG LA-E-006.
- SLAVE UNIT CIRCUIT SHOWN FEEDING THESE FIXTURES IS FROM L-CS-144-LP-01 VIA TYPE F-30 FIXTURE SHOWN ON THIS DWG.

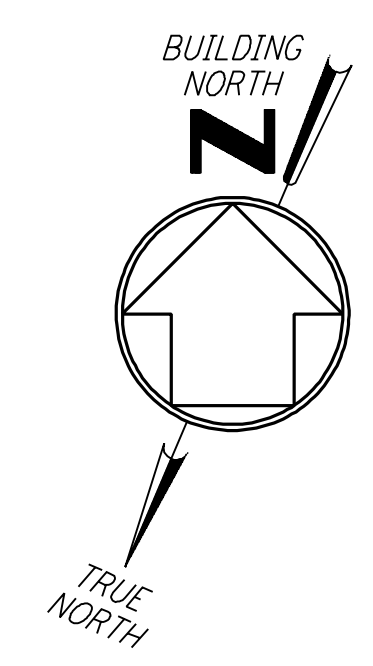

KEY PLAN  
**LIGO-D961010-01-0**

This document and the design it covers are the property of PARSONS. They are loaned only with the borrower's expressed written agreement that they will not be reproduced, copied, loaned, exhibited, or used in any other way, except by written consent from PARSONS to the borrower.

NO.	DATE	BY	CHKD	ENGR	PROJ	DESCRIPTION
1	8-7-98	JE				ISSUED FOR AS-BUILT

ISSUED FOR CONSTRUCTION		
DRAWN	M. M.	11-15-96
CHECKED	KCL	7-24-96
ENGINEER	KCR	10-25-96
PROJ	T. D. M.	11-15-96
<b>AS-BUILT DRAWINGS</b>		

**PARSONS**  
 100 WEST WALNUT STREET  
 PASADENA, CALIFORNIA

**LIGO**  
 CALIFORNIA INSTITUTE OF TECHNOLOGY  
 MASSACHUSETTS INSTITUTE OF TECHNOLOGY

LASER INTERFEROMETER  
 GRAVITATIONAL-WAVE OBSERVATORY  
 SITE NO. 2 - LIVINGSTON, LOUISIANA

TITLE	SCALE	CONTRACT NUMBER	PROJECT NUMBER
ELECTRICAL CORNER STATION OSB LAB AREA LIGHTING PLAN	AS NOTED	PP150969	8094
SHEET NUMBER	REVISIONS		
<b>LA-E-108</b>			