

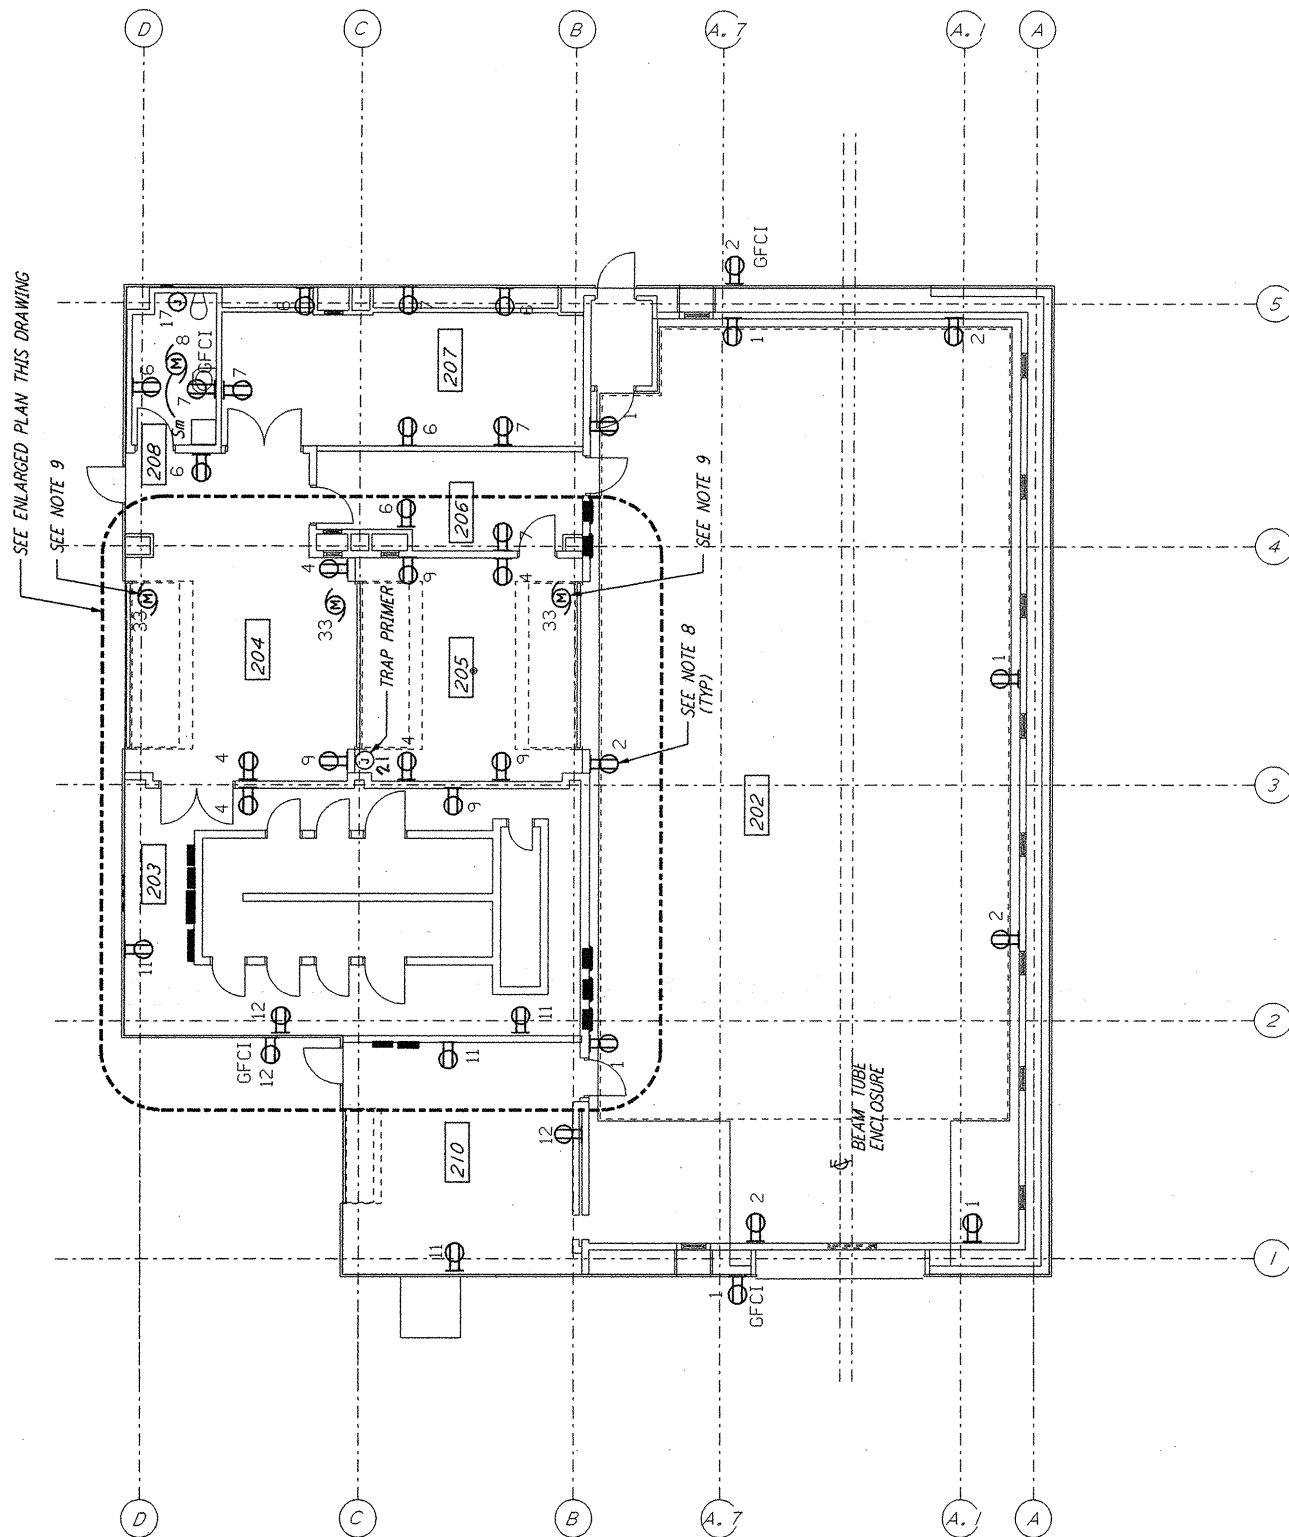




THIS DOCUMENT AND THE DESIGN IT CONTAINS ARE THE PROPERTY OF PARSONS. THEY ARE LOANED ONLY WITH THE BORROWER'S EXPRESSED WRITTEN AGREEMENT THAT THEY WILL NOT BE REPRODUCED, COPIED, ISSUED, EITHERED, OR USED IN ANY OTHER WAY, EXCEPT BY WRITTEN CONSENT FROM PARSONS TO THE BORROWER.

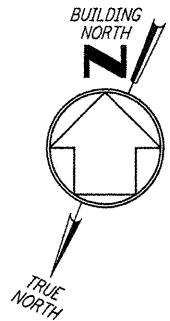

**POWER PLAN**  
1/8" = 1'-0"

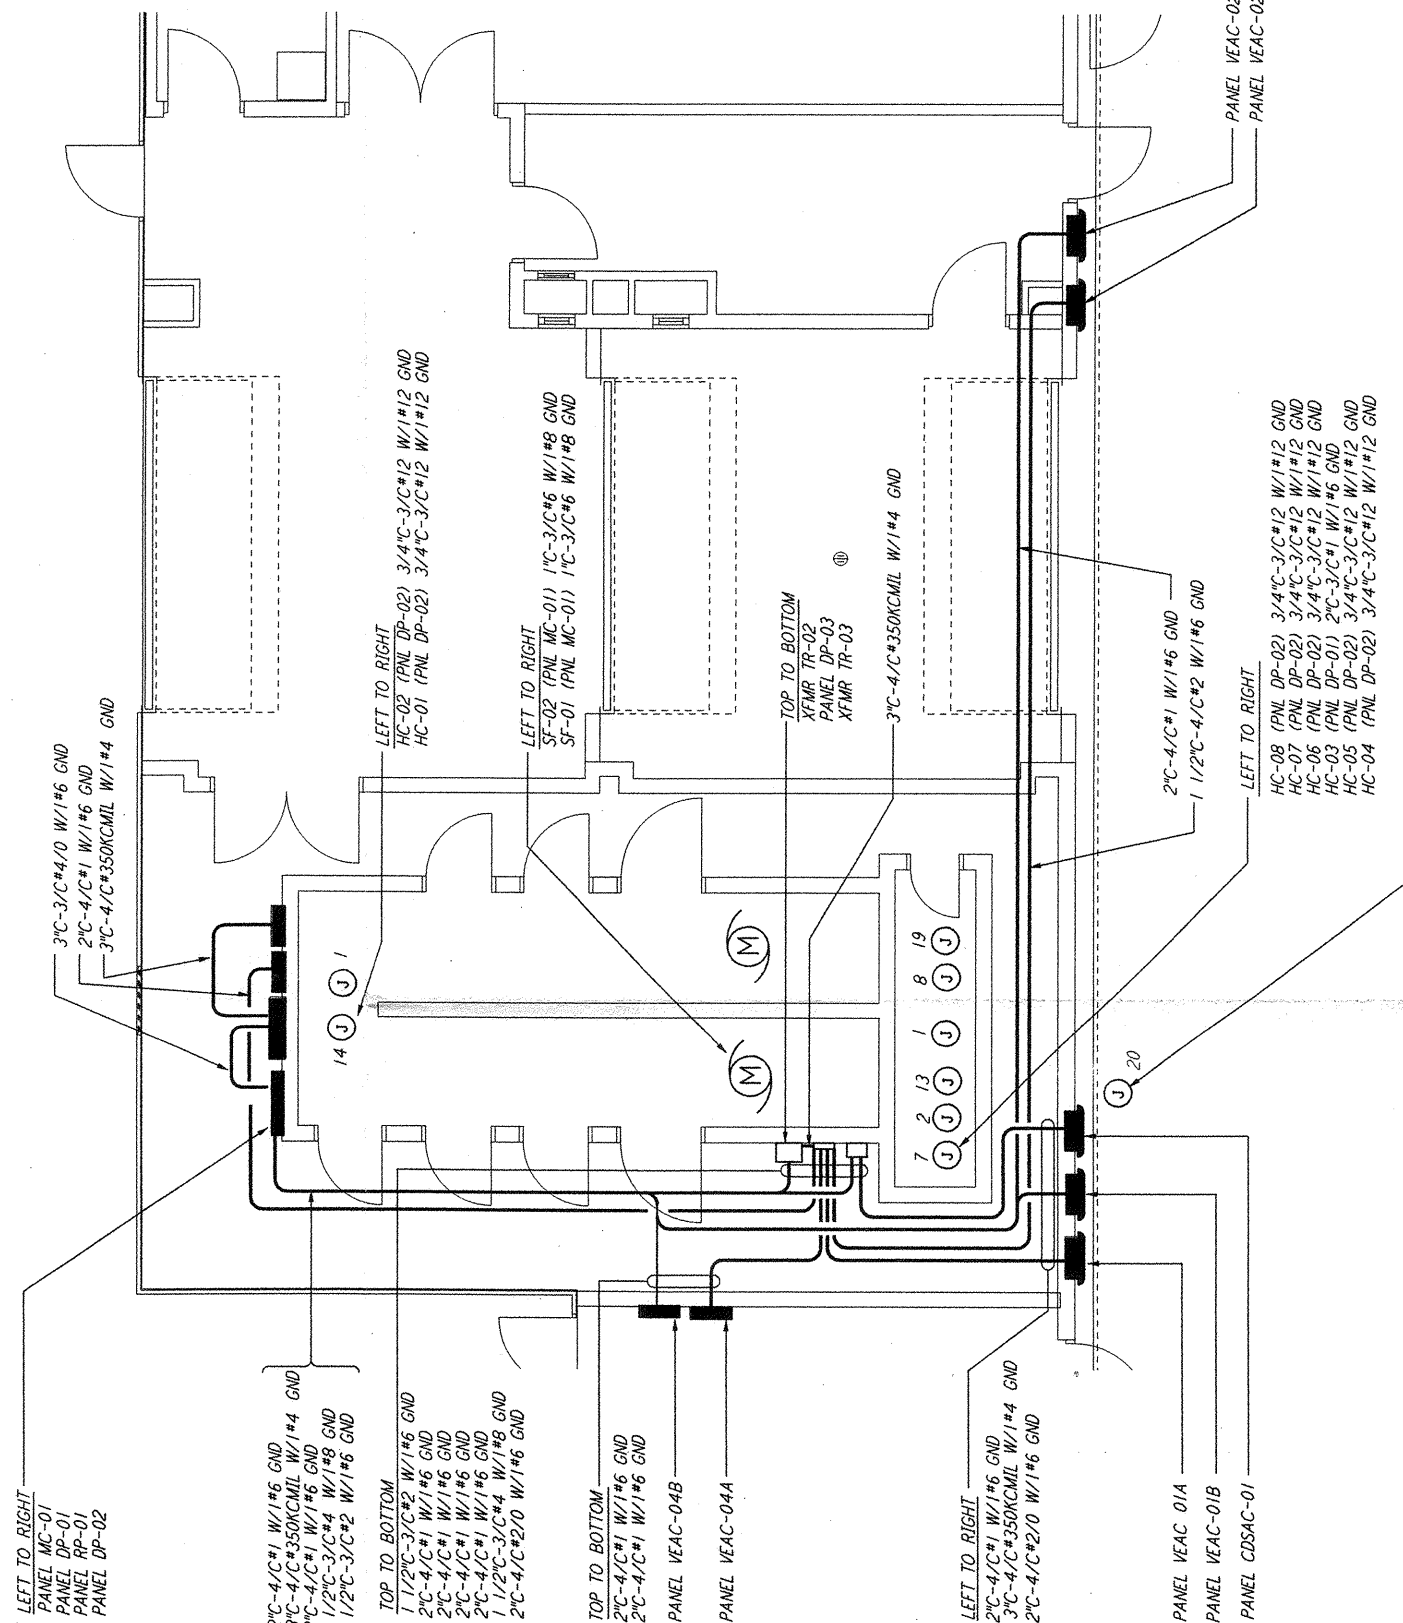


  **ENLARGED PLAN**  
1/4" = 1'-0"



**NOTES:**

1. FOR STANDARD SYMBOLS, ABBREVIATIONS AND ACRONYMS SEE DWG. LA-E-001.
2. FOR ELECTRICAL SYMBOLS SEE DWG. LA-E-002.
3. FOR STANDARD INSTALLATION DETAILS SEE DWG. LA-E-404 AND LA-E-409.
4. FOR CABLE TYPE DESCRIPTION SEE DWG. LA-E-007.
5. ALL CONDUIT RUNS ARE SHOWN DIAGRAMMATICALLY ONLY. CONTRACTOR SHALL COORDINATE INSTALLATION WITH OTHER DISCIPLINES.
6. FOR SINGLE LINE DIAGRAM, SEE DWG. LA-E-008.
7. FOR EQUIPMENT LOCATION, SEE HVAC DWG. LA-H-211.
8. ALL CIRCUITS SHOWN ON THIS DRAWING ARE FROM PANEL RP01 UNLESS OTHERWISE NOTED.
9. CIRCUIT SHOWN FEEDING THESE ITEMS ARE FROM DP-02.
10. PANEL SCHEDULES ARE SHOWN ON DRAWINGS LA-E-205 AND LA-E-206.

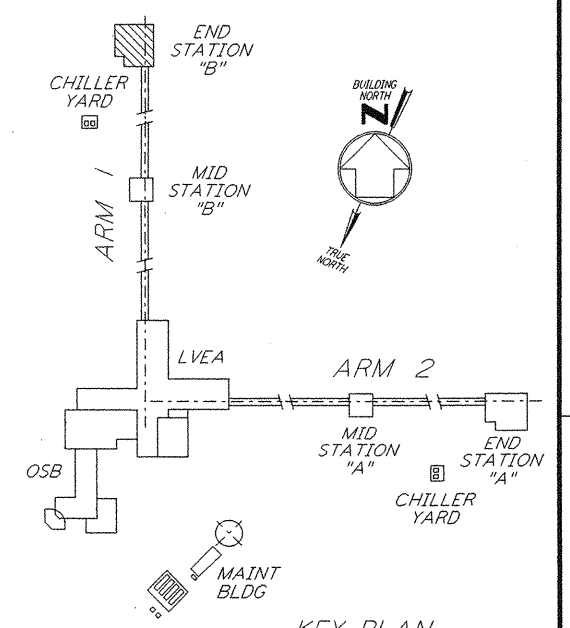

**KEY PLAN**  
LIGO-D961035-02-0

NO.	DATE	BY	CHKD	ENGR	PROJ	DESCRIPTION
2	8-7-98	JE	R.K.	AK	W.W.	ISSUED FOR AS-BUILT
1	2-28-97	J.G.	RDC	KCP	F.D.M.	GENERAL REVISIONS

NO.	DATE	BY	CHKD	ENGR	PROJ	DESCRIPTION
1	11-15-96	M.M.	J.C.L.	K.C.R.	T.D.M.	ISSUED FOR CONSTRUCTION

**AS-BUILT DRAWINGS**

**PARSONS**  
100 WEST WALNUT STREET  
PASADENA, CALIFORNIA

**LIGO**  
CALIFORNIA INSTITUTE OF TECHNOLOGY  
MASSACHUSETTS INSTITUTE OF TECHNOLOGY

TITLE	SCALE	CONTRACT NUMBER	PROJECT NUMBER
ELECTRICAL END STATION B ABOVEGROUND POWER PLAN	AS NOTED	PP150969	8094

LA-E-214