

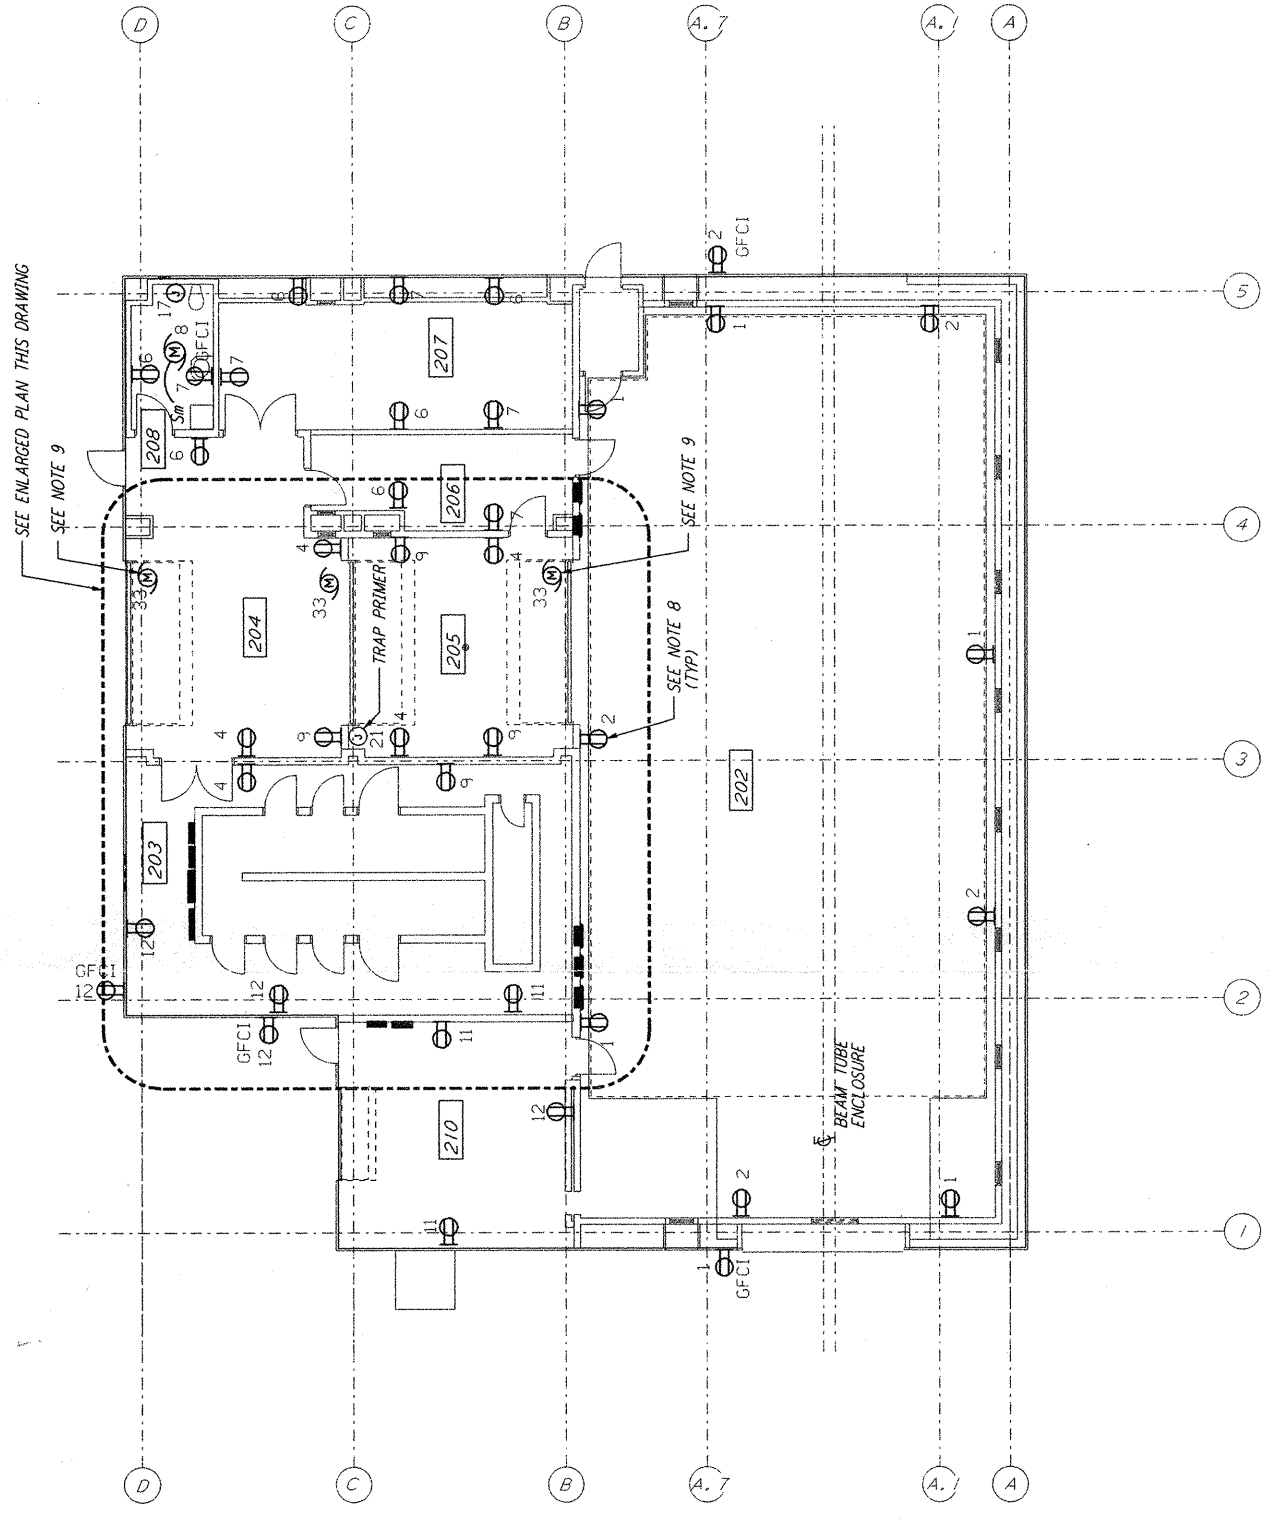


NOTES:


- FOR STANDARD SYMBOLS, ABBREVIATIONS AND ACRONYMS SEE DWG. LA-E-001.
- FOR ELECTRICAL SYMBOLS SEE DWG. LA-E-002.
- FOR STANDARD INSTALLATION DETAILS SEE DWG. LA-E-404 AND LA-E-403.
- FOR CABLE TYPE DESCRIPTION SEE DWG. LA-E-007.
- ALL CONDUIT RUNS ARE SHOWN DIAGRAMMATICALLY ONLY. CONTRACTOR SHALL COORDINATE INSTALLATION WITH OTHER DISCIPLINES.
- FOR SINGLE LINE DIAGRAM, SEE DWG. LA-E-008.
- FOR EQUIPMENT LOCATION, SEE HVAC DWG. LA-H-211.
- ALL CIRCUITS SHOWN ON THIS DRAWING ARE FROM PANEL RP01 UNLESS OTHERWISE NOTED.
- CIRCUIT SHOWN FEEDING THESE ITEMS ARE FROM DP-02.
- PANEL SCHEDULES ARE SHOWN ON DRAWINGS LA-E-205 AND LA-E-206.

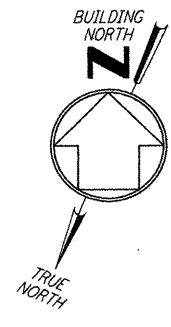


POWER PLAN
 1/8" = 1'-0"

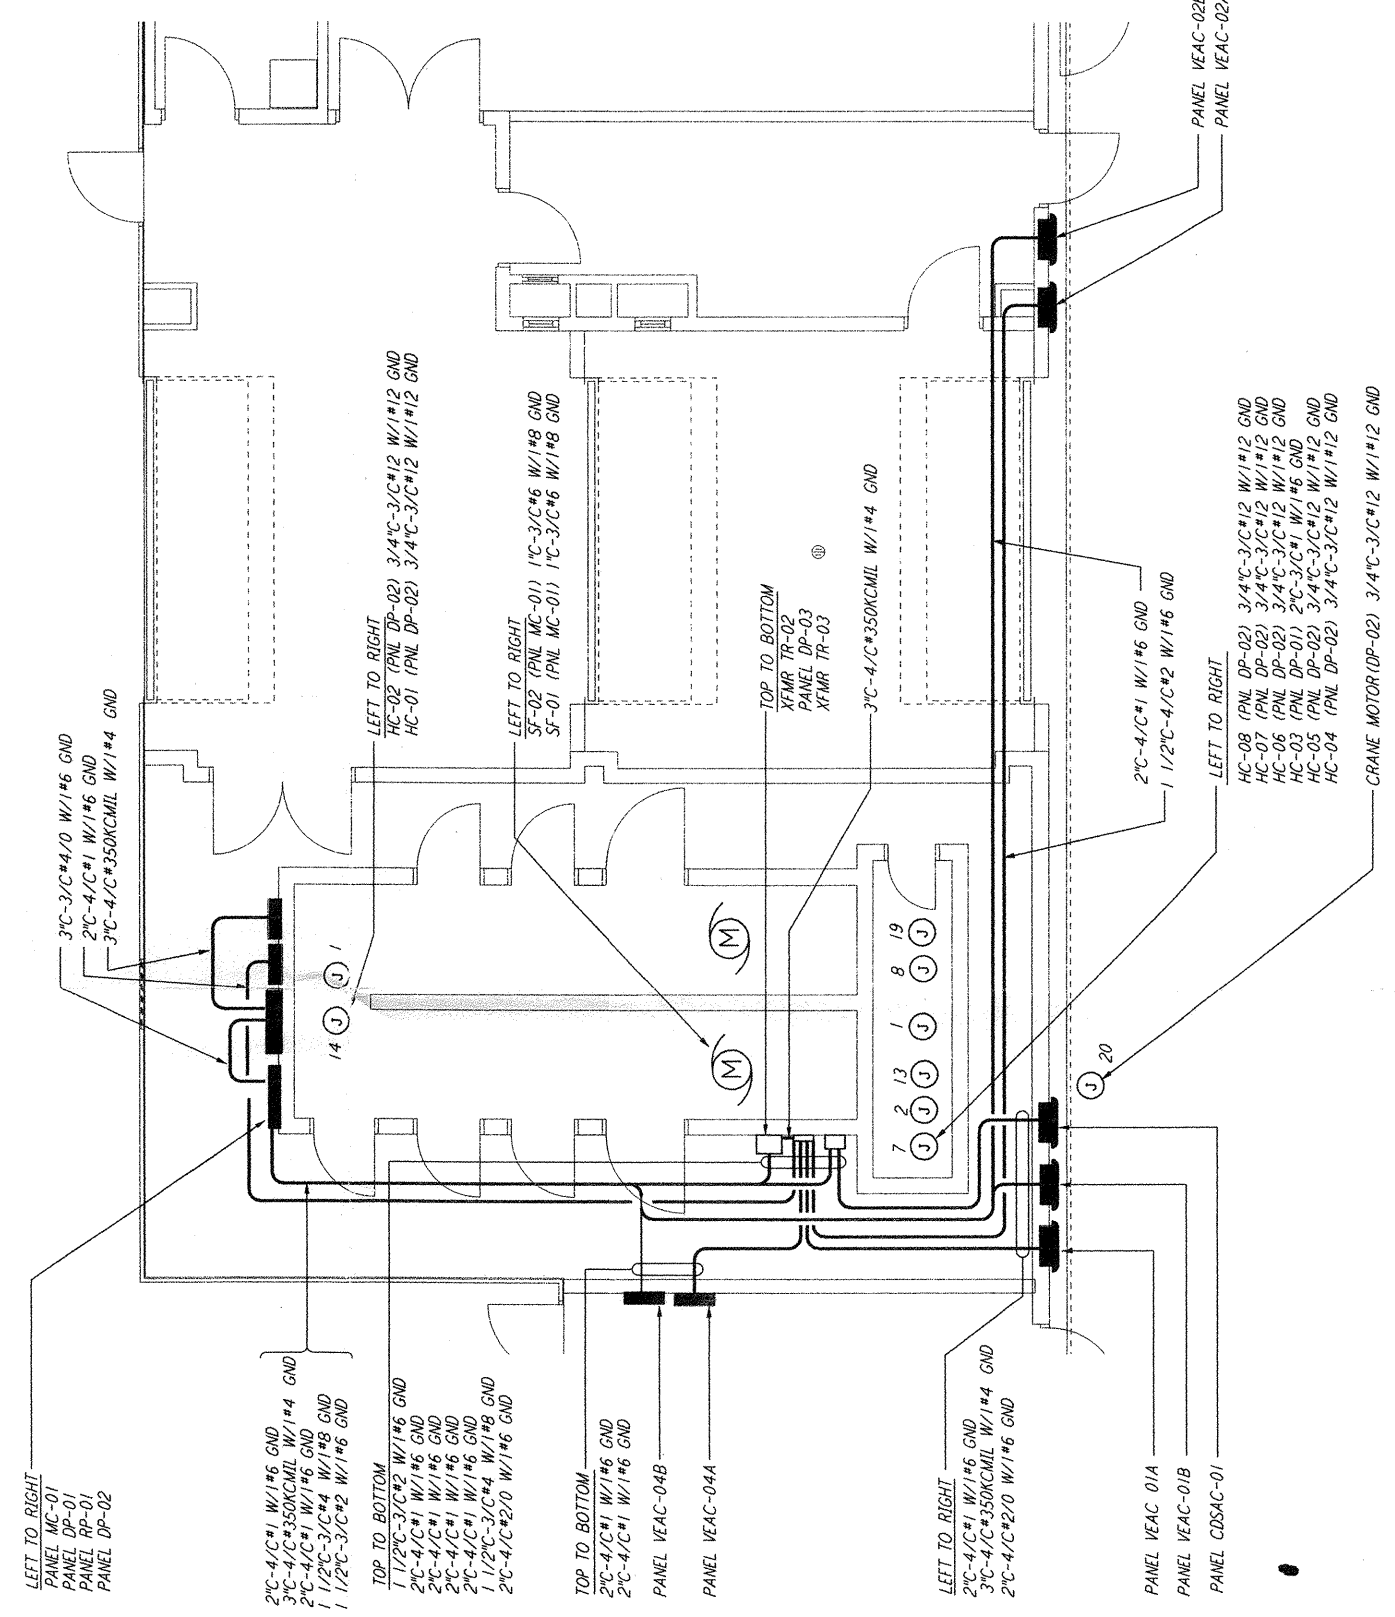

ENLARGED PLAN
 1/4" = 1'-0"

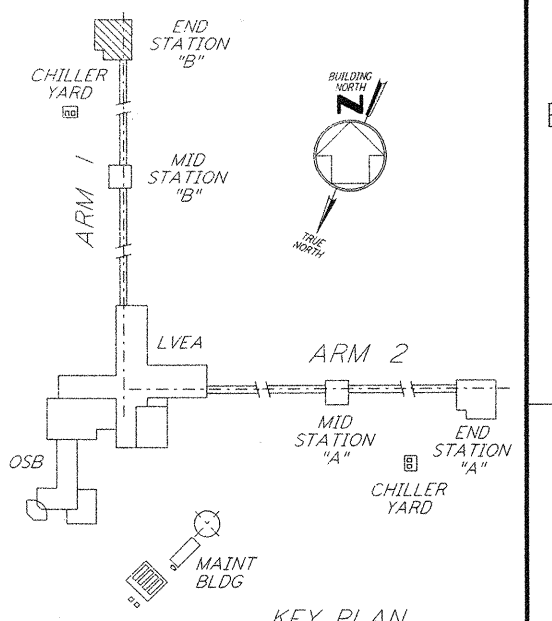

KEY PLAN

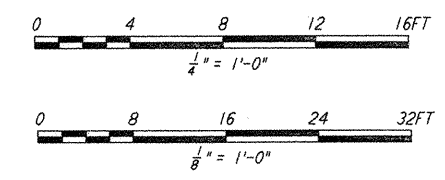

NO.	DATE	BY	CHKD	ENGR	PROJ	DESCRIPTION
3	5-21-99	AO	AK	AG	MKW	ISSUED AS REVISED AS-BUILT
2	8-7-98	JE	AK	AG	MKW	ISSUED FOR AS-BUILT
1	2-28-97	J.G.	RDC	KCR	T.D.M.	GENERAL REVISIONS

ISSUED FOR CONSTRUCTION		
DRAWN	M. M.	11-15-96
CHECKED	J. C. L.	7-24-96
ENGINEER	K. C. R.	10-25-96
PROJ	T. D. M.	11-15-96

AS-BUILT DRAWINGS

PARSONS
 100 WEST WALNUT STREET
 PASADENA, CALIFORNIA

LIGO
 CALIFORNIA INSTITUTE OF TECHNOLOGY
 MASSACHUSETTS INSTITUTE OF TECHNOLOGY

LIGO-D961035-03-O

LASER INTERFEROMETER
 GRAVITATIONAL-WAVE OBSERVATORY
 SITE NO.2 - LIVINGSTON, LOUISIANA

TITLE	SCALE	COURTESY NUMBER	PROJECT NUMBER
ELECTRICAL END STATION B ABOVEGROUND POWER PLAN	AS NOTED	PP150969	8094
SHEET NUMBER			REVISIONS
LA-E-214			3

This document and the design it covers are the property of PARSONS. They are loaned only with the borrower's expressed written agreement that they will not be reproduced, copied, loaned, exhibited, or used in any other way, except by written consent from PARSONS to the borrower.