


REVISION VERSION - NOT FOR CONSTRUCTION USE

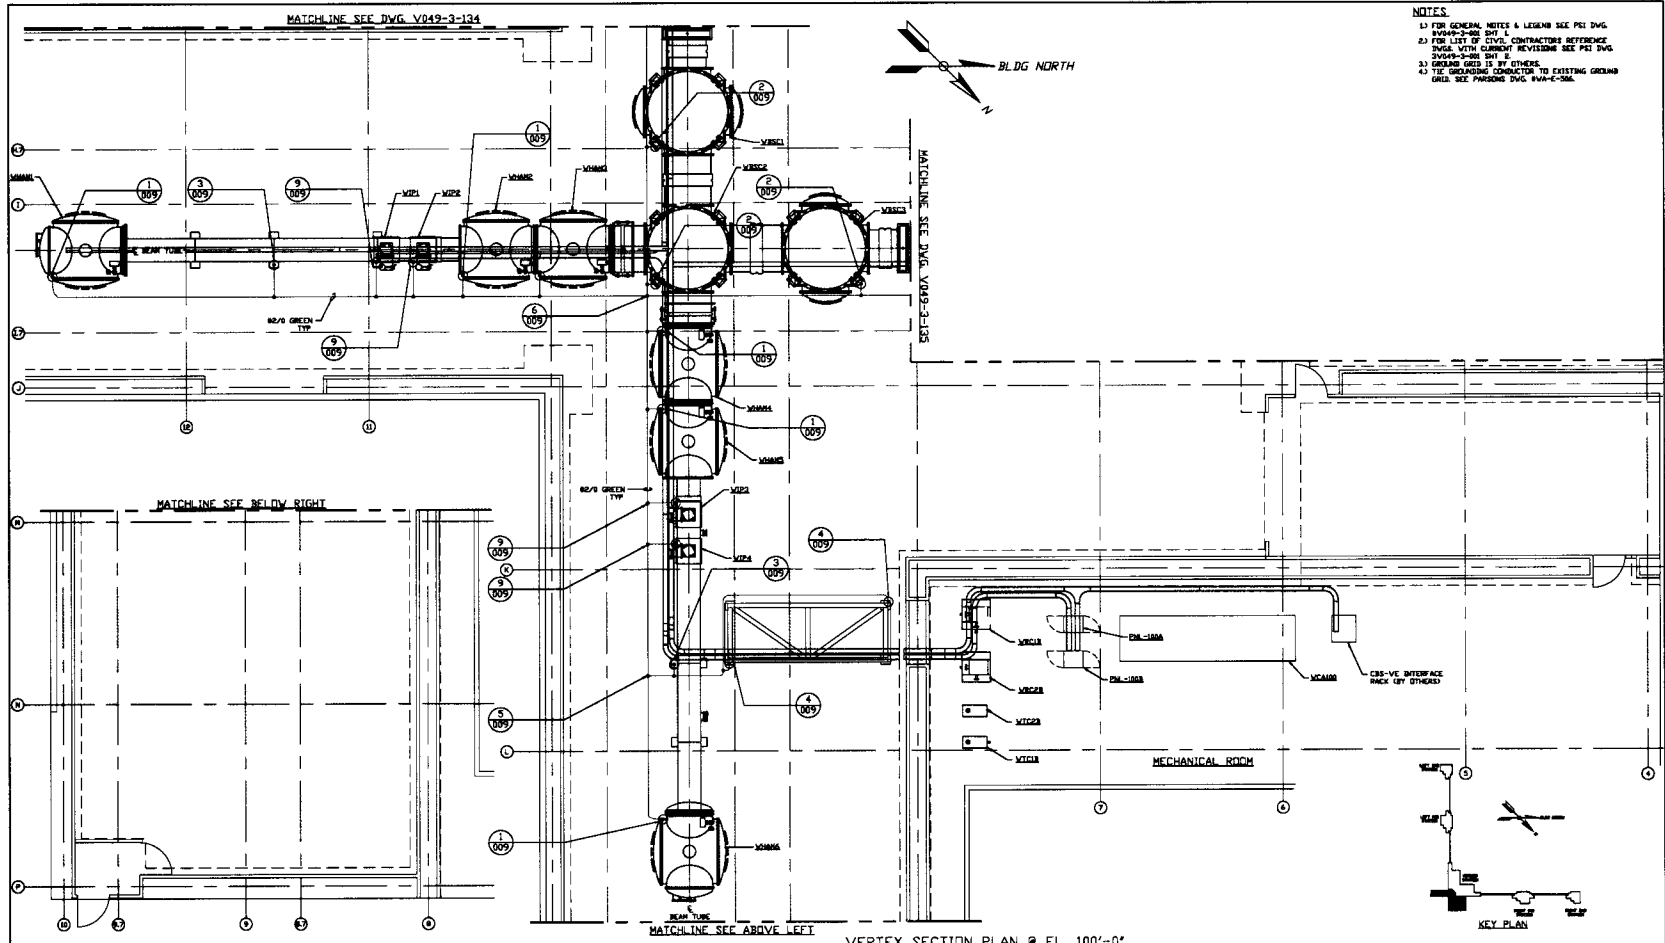

**NOTES**  
 1) FOR GENERAL NOTES & LEGEND SEE P&I DWG. V049-3-001  
 2) FOR LIST OF LEVEL CONTRACTORS REFERENCE DWG. WITH CURRENT REVISIONS SEE P&I DWG. V049-3-001 E  
 3) GROUND GRID IS BY OTHERS.  
 4) THE GROUNDING CONDUCTOR TO EXISTING GROUND GRID. SEE PARAS. DWG. V04-E-001.

DWG. NO.	DESCRIPTION	DWG. NO.	DESCRIPTION	ISSUE NO.	ISSUE DESCRIPTION	CHKD.	DRWN.	DATE	SCALE	SHEET
V049-3-133	GROUNDING PLAN WASHINGTON RIGHT BEAM MANIFOLD			1	ISSUE FOR AS BUILT				3/16" = 1' - 0"	1 OF 1
V049-3-134	GROUNDING PLAN WASHINGTON LEFT BEAM MANIFOLD			1	ISSUE FOR AS BUILT					
V049-3-135	CABLE TRAY PLAN WASHINGTON VORTEX SECTION			1	ISSUE FOR CONSTRUCTION					
V049-3-001	GROUNDING DETAILS			1	ISSUE FOR F&I UPDATE & RED					
V049-3-002	WASHINGTON OVERALL SITE PLAN			1	ISSUE FOR F&I UPDATE & RED					
V049-3-003	GENERAL NOTES & LEGEND			1	ISSUE FOR F&I UPDATE & RED					

LIGO-D970339-02-V